


A
002

SECOND FLOOR PLAN

SCALE 1/4"=1'-0"

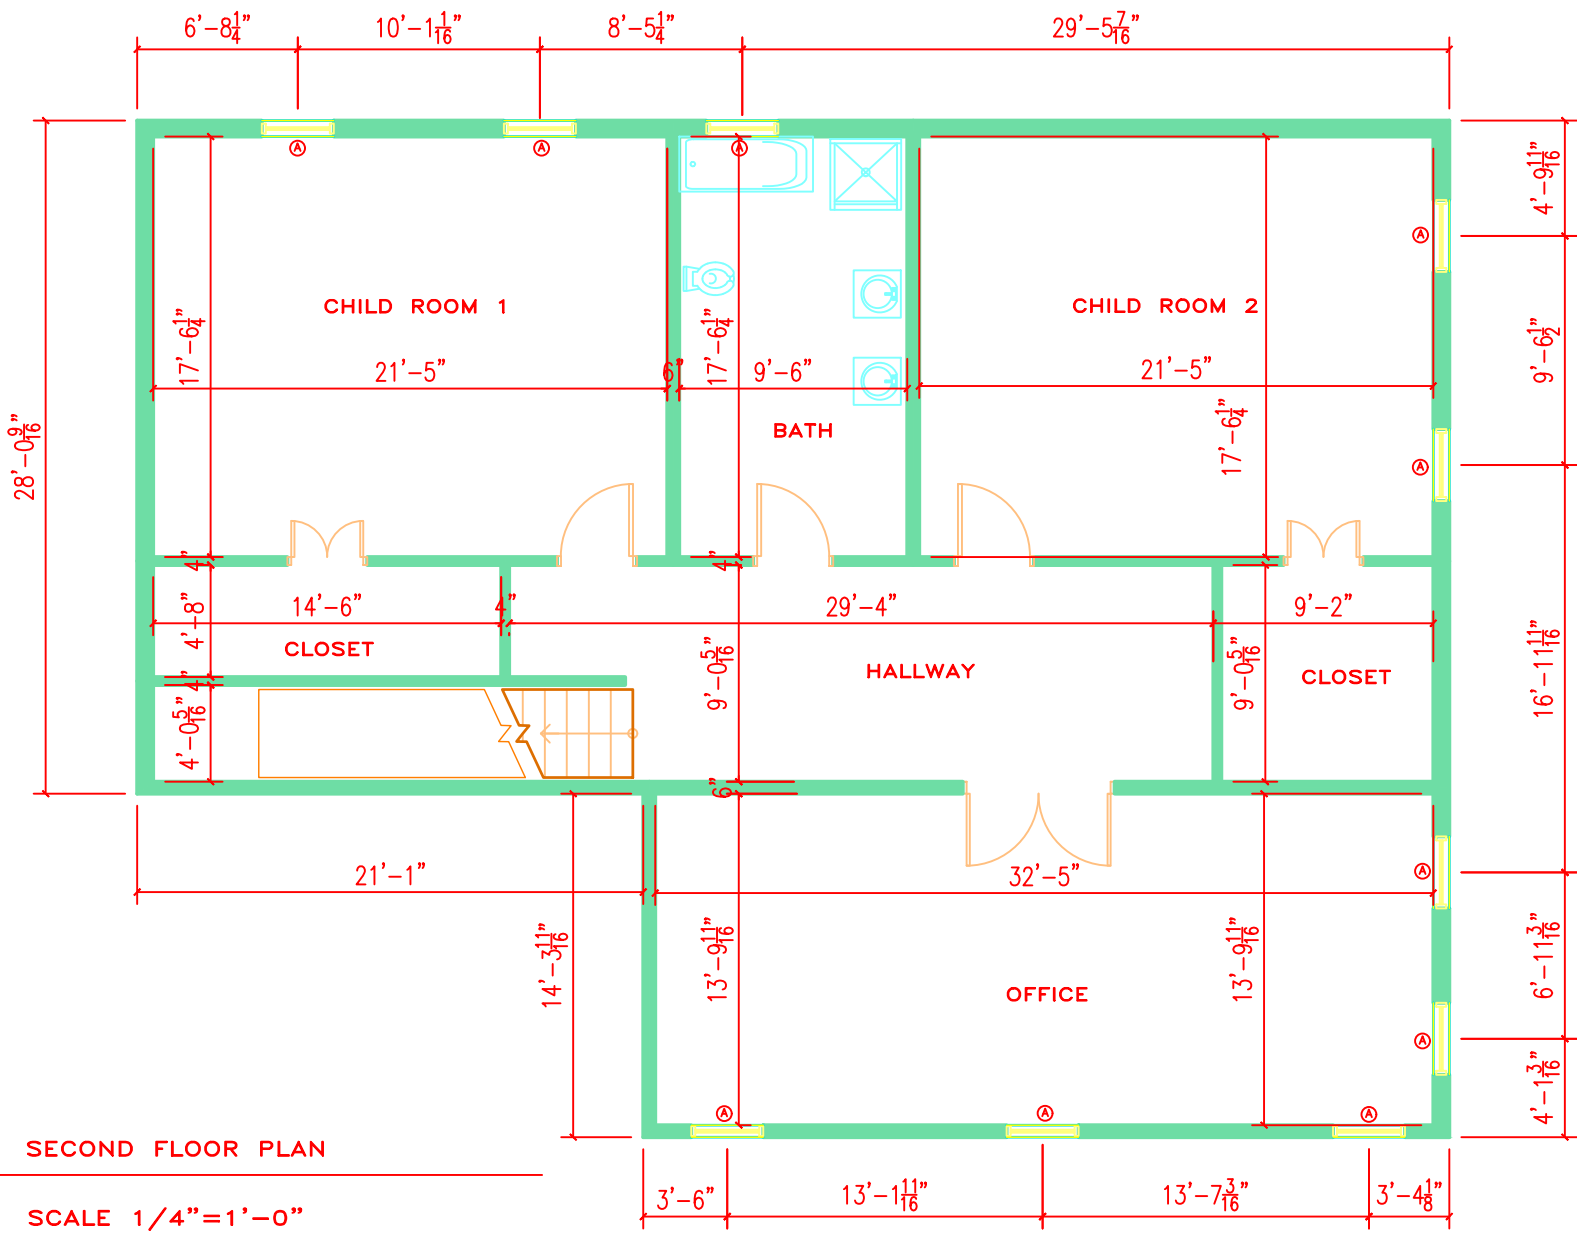

SHEET TITLE


ROSANN ROMANO

PROJECT 1

SCALE 1/4

DRAWING

REF: _____
PROJECT NO: _____
DATE: _____
FILE: SITE_PLAN PROJ 1A
CONSTRUCTION
DESIGN 3.20.17.DWG
DRAWN BY: _____
CHK'D BY: _____

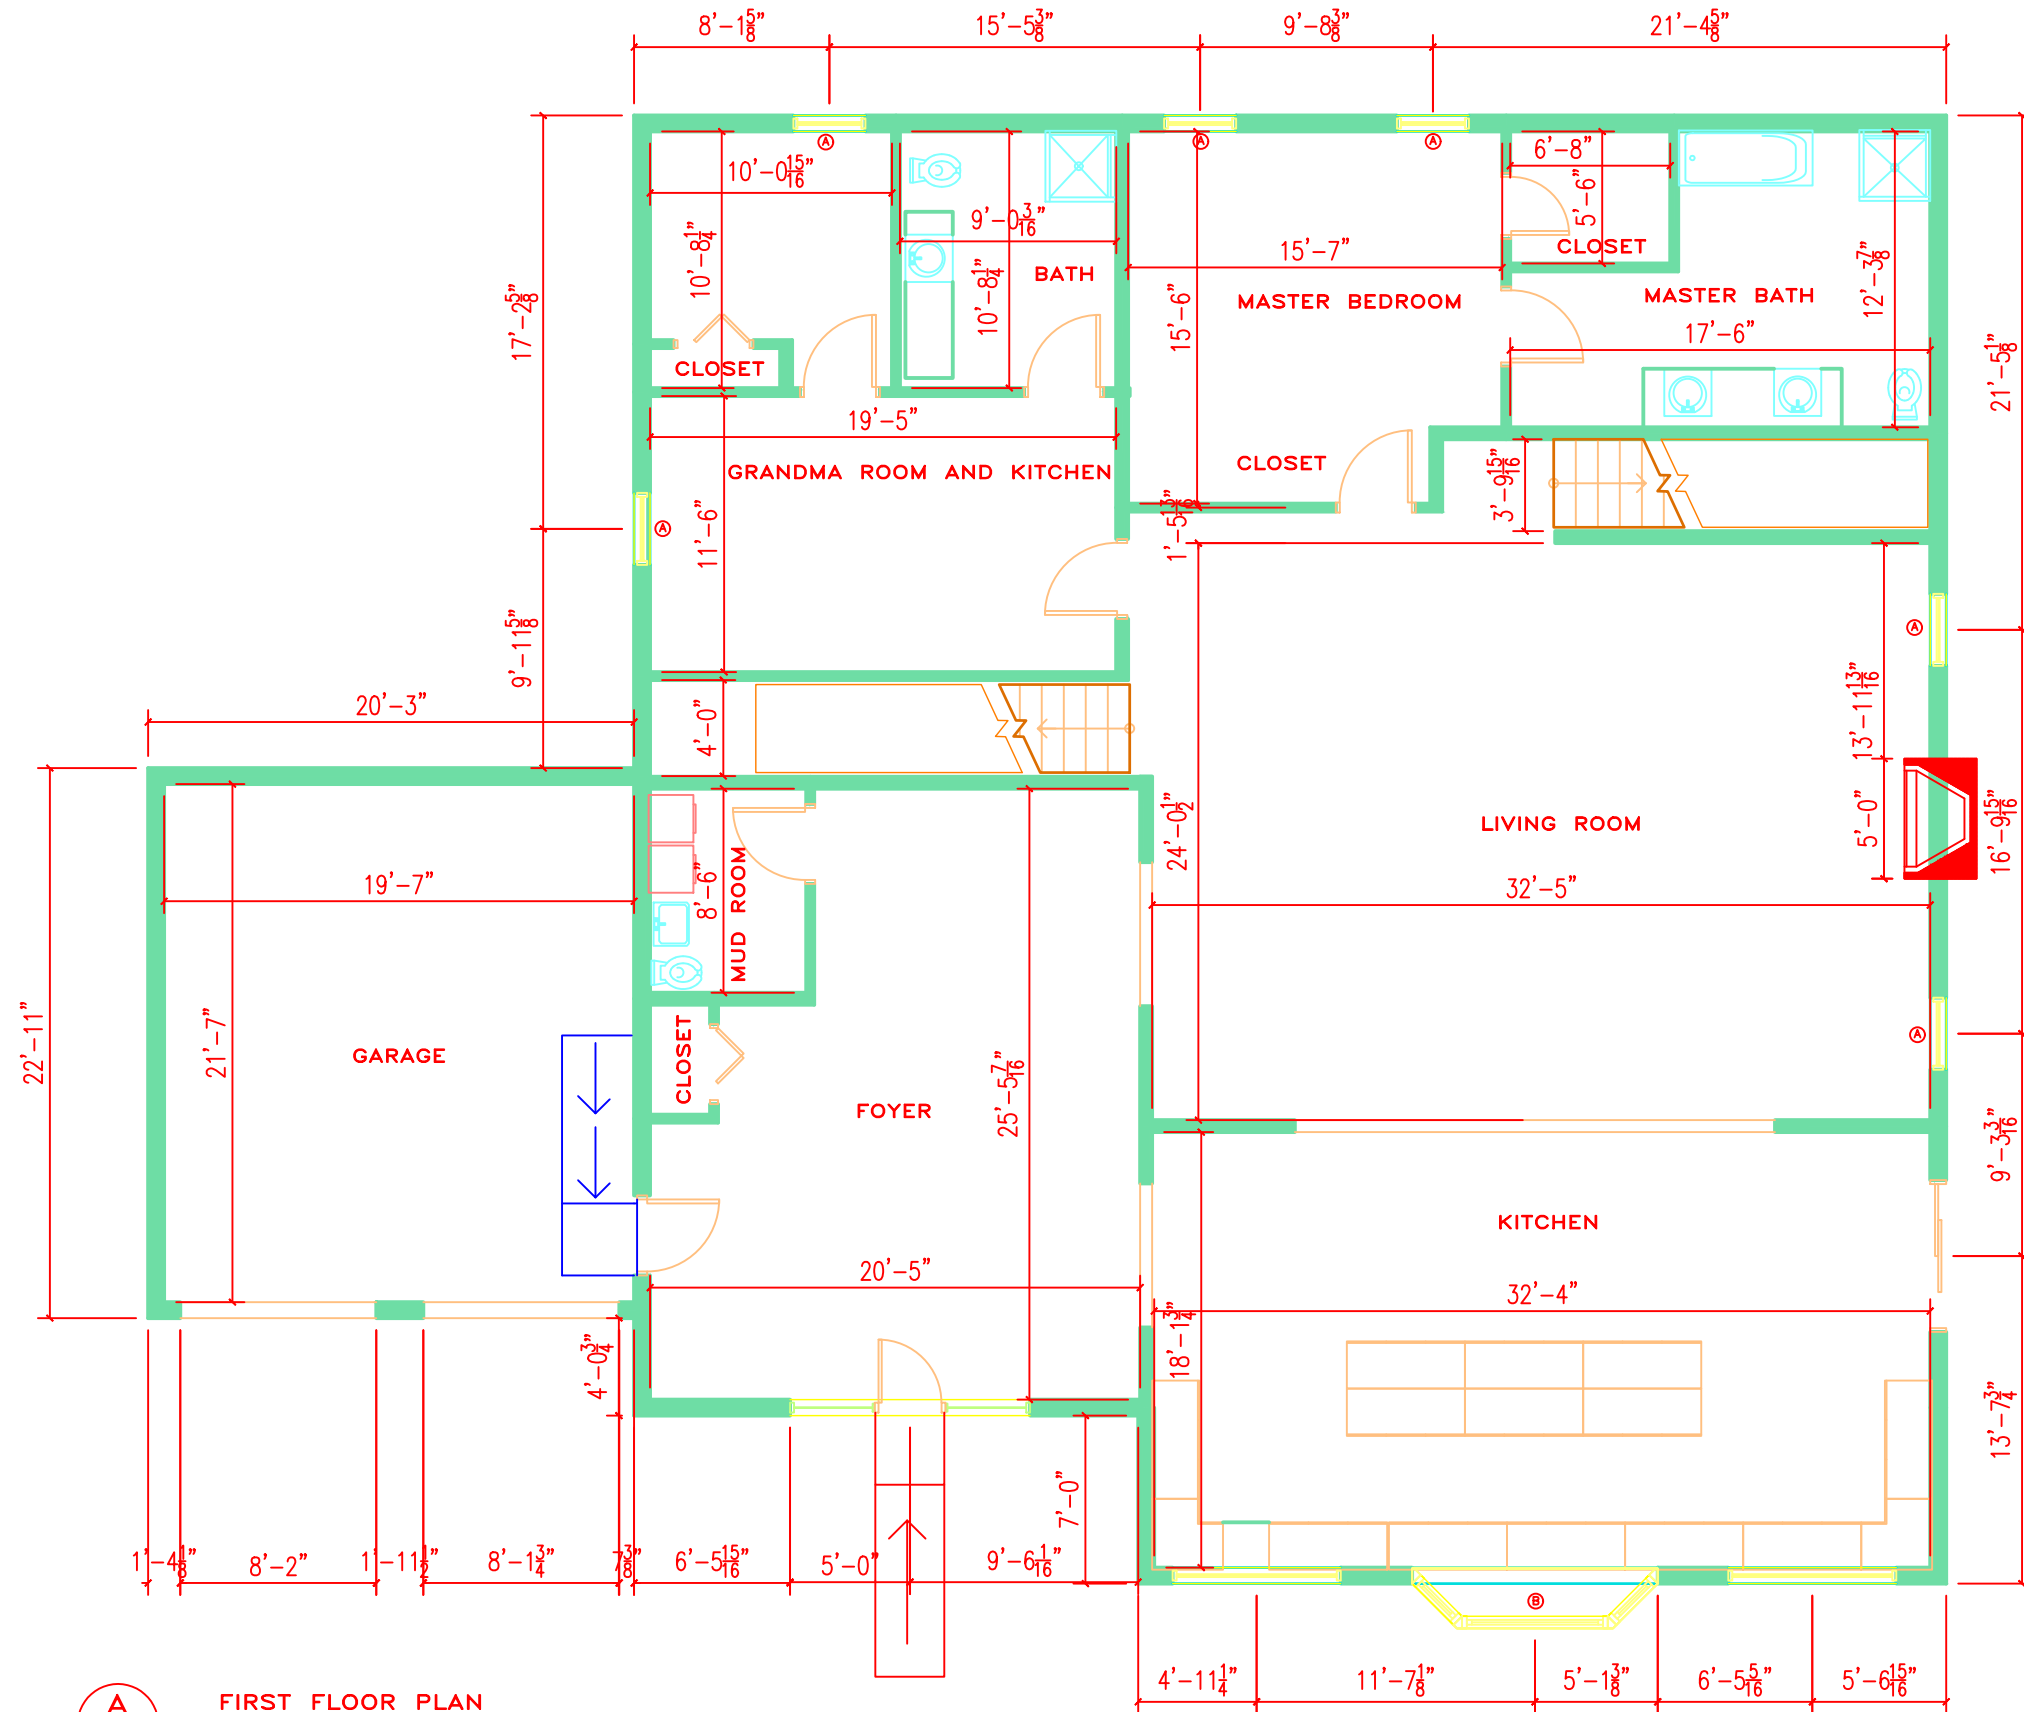

A
001

FIRST FLOOR PLAN

SCALE 1/4"=1'-0"

SHEET TITLE

ROSANN ROMANO

PROJECT 1

SCALE 1/4

REF:	PROJECT NO:
DATE:	FILE: SITE PLAN PROJ 1A
	CONSTRUCTION
	DESIGN 3.20.17.DWG
DRAWN BY:	CHK'D BY:

DRAWING

PROJECT 1: RESIDENTIAL AUTOCAD WORKING DRAWINGS

ROSANN ROMANO
CONSTRUCTION DESIGN (ARC272)
SPRING 2017
PROFESSOR LOPICCOLO

TABLE R301.2(1) CLIMATE AND GEOGRAPHICAL DESIGN CRITERIA

GROUND SNOW LOAD	WIND SPEED (MPH)	SEISMIC DESIGN CATEGORY ^e	SUBJECT TO DAMAGE FROM			ICE BARRIER UNDERLAYMENT REQUIRED ^g	FLOOD HAZAEDS ^f
			WEATHERING ^a	FROST LINE DEPTH ^b	TERMITE ^c		

SHEET TITLE

ROSANN ROMANO

PROJECT

PROJECT 1

SCALE

1/4

DRAWING

REF:

PROJECT NO:

DATE:

FILE: SITE PLAN PROJ 1A
CONSTRUCTION
DESIGN 3.20.17.DWG

DRAWN BY:

CHK'D BY:

FIXTURE KEY	
	KITCHEN SINK
	WASHER
	DRYER
	SLOP SINK
	REFRIGERATOR
	BATHROOM SINK
	BATH TUB
	SHOWER
	RANGE/OVEN
	WINDOW
	SOLID CORE DOOR

DOOR SCHEDULE				
NO.	MANUF.	SIZE	TYPE	R.O.
①	JELD-WEN	3'x6'-8"	FRONT DOOR	3'-2"x6'-10"
②	JELD-WEN	3'x6'-8"	STANDARD DOOR	3'-2"x6'-10"
③	AMAR2731	8'-2"	GARAGE DOOR	N/A

WINDOW SCHEDULE			
NUMBER	MANUF./ CAT. NO.	TYPE	R.O.
Ⓐ	ANDERSON 400-SERIES/TW3636	DOUBLE HUNG	3'-2"x5'
Ⓑ	TAFCO	BAY WINDOW	8'-11"-3'

FINISH SCHEDULE						
ROOM	WALLS	TRIM	FLOOR	BASE	CEILING	CLG. HT.
DINING	PAINT	WHITE PAINTED	HARDWOOD	WHITE PAINTED	PAINT	8'-0"
KITCHEN			TILE			
LIVING			HARDWOOD			
BEDRM. 1			CARPET			
BEDRM. 2			CARPET			
BEDRM. 3			CARPET			
BEDRM. 3			CARPET			
BATH			TILE			
LAUNDRY			TILE			

SHEET TITLE


ROSANN ROMANO

PROJECT 1

SCALE 1/4

REF: _____
PROJECT NO: _____
DATE: _____
FILE: SITE_PLAN PROJ 1A
CONSTRUCTION
DESIGN 3.20.17.DWG
DRAWN BY: _____
CHK'D BY: _____

DRAWING

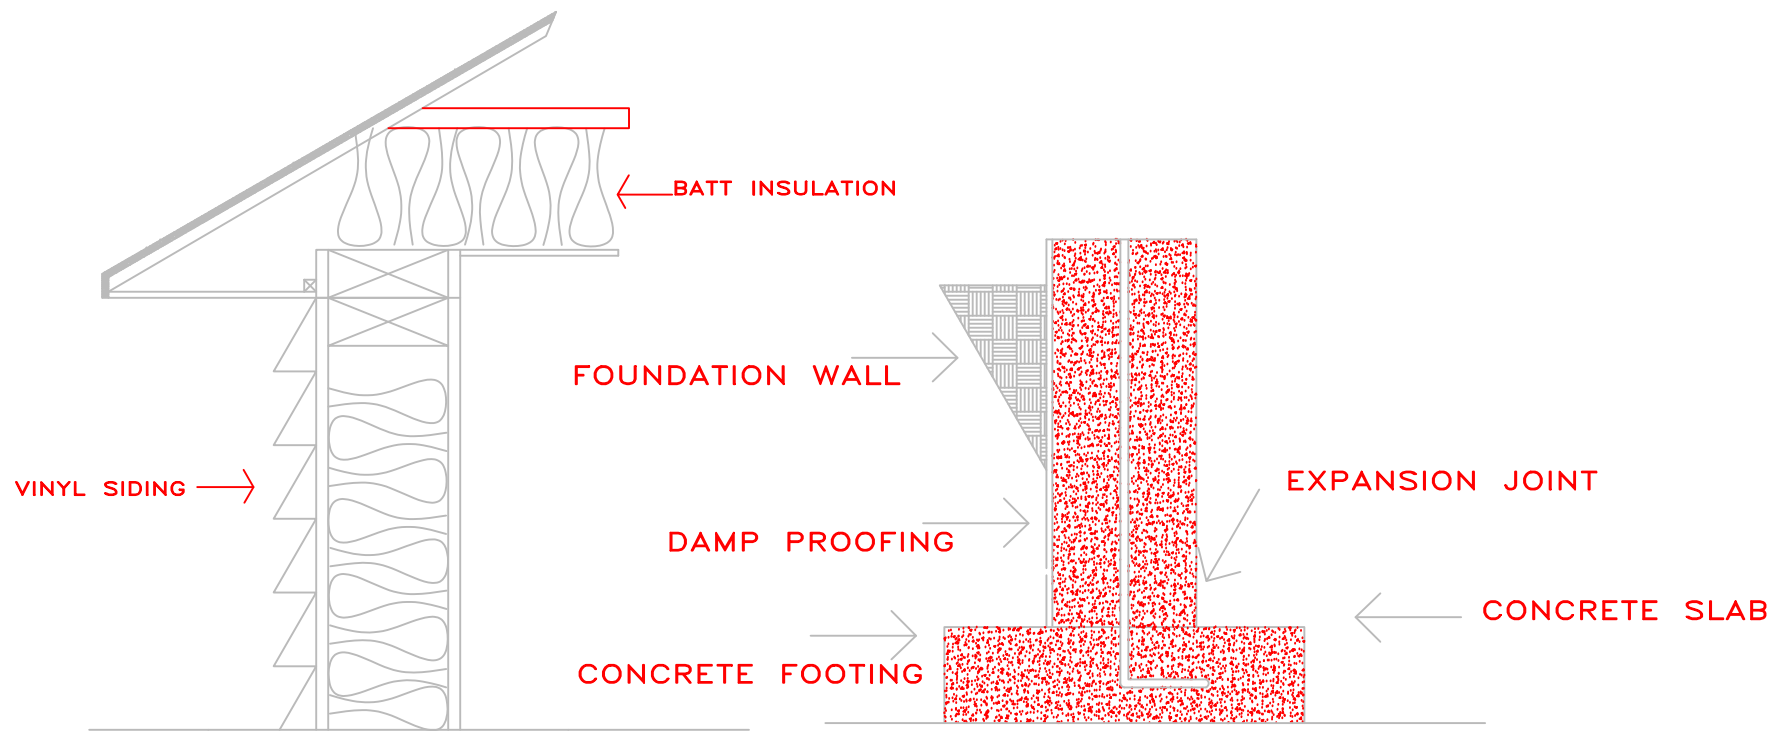

A
014

WALL SECTION

SCALE 1/4"=1'-0"

SHEET TITLE


ROSANN ROMANO

PROJECT 1

SCALE 1/4

DRAWING

REF: _____
PROJECT NO: _____
DATE: _____
FILE: SITE_PLAN PROJ 1A
CONSTRUCTION
DESIGN 3.20.17.DWG
DRAWN BY: 
CHK'D BY: 

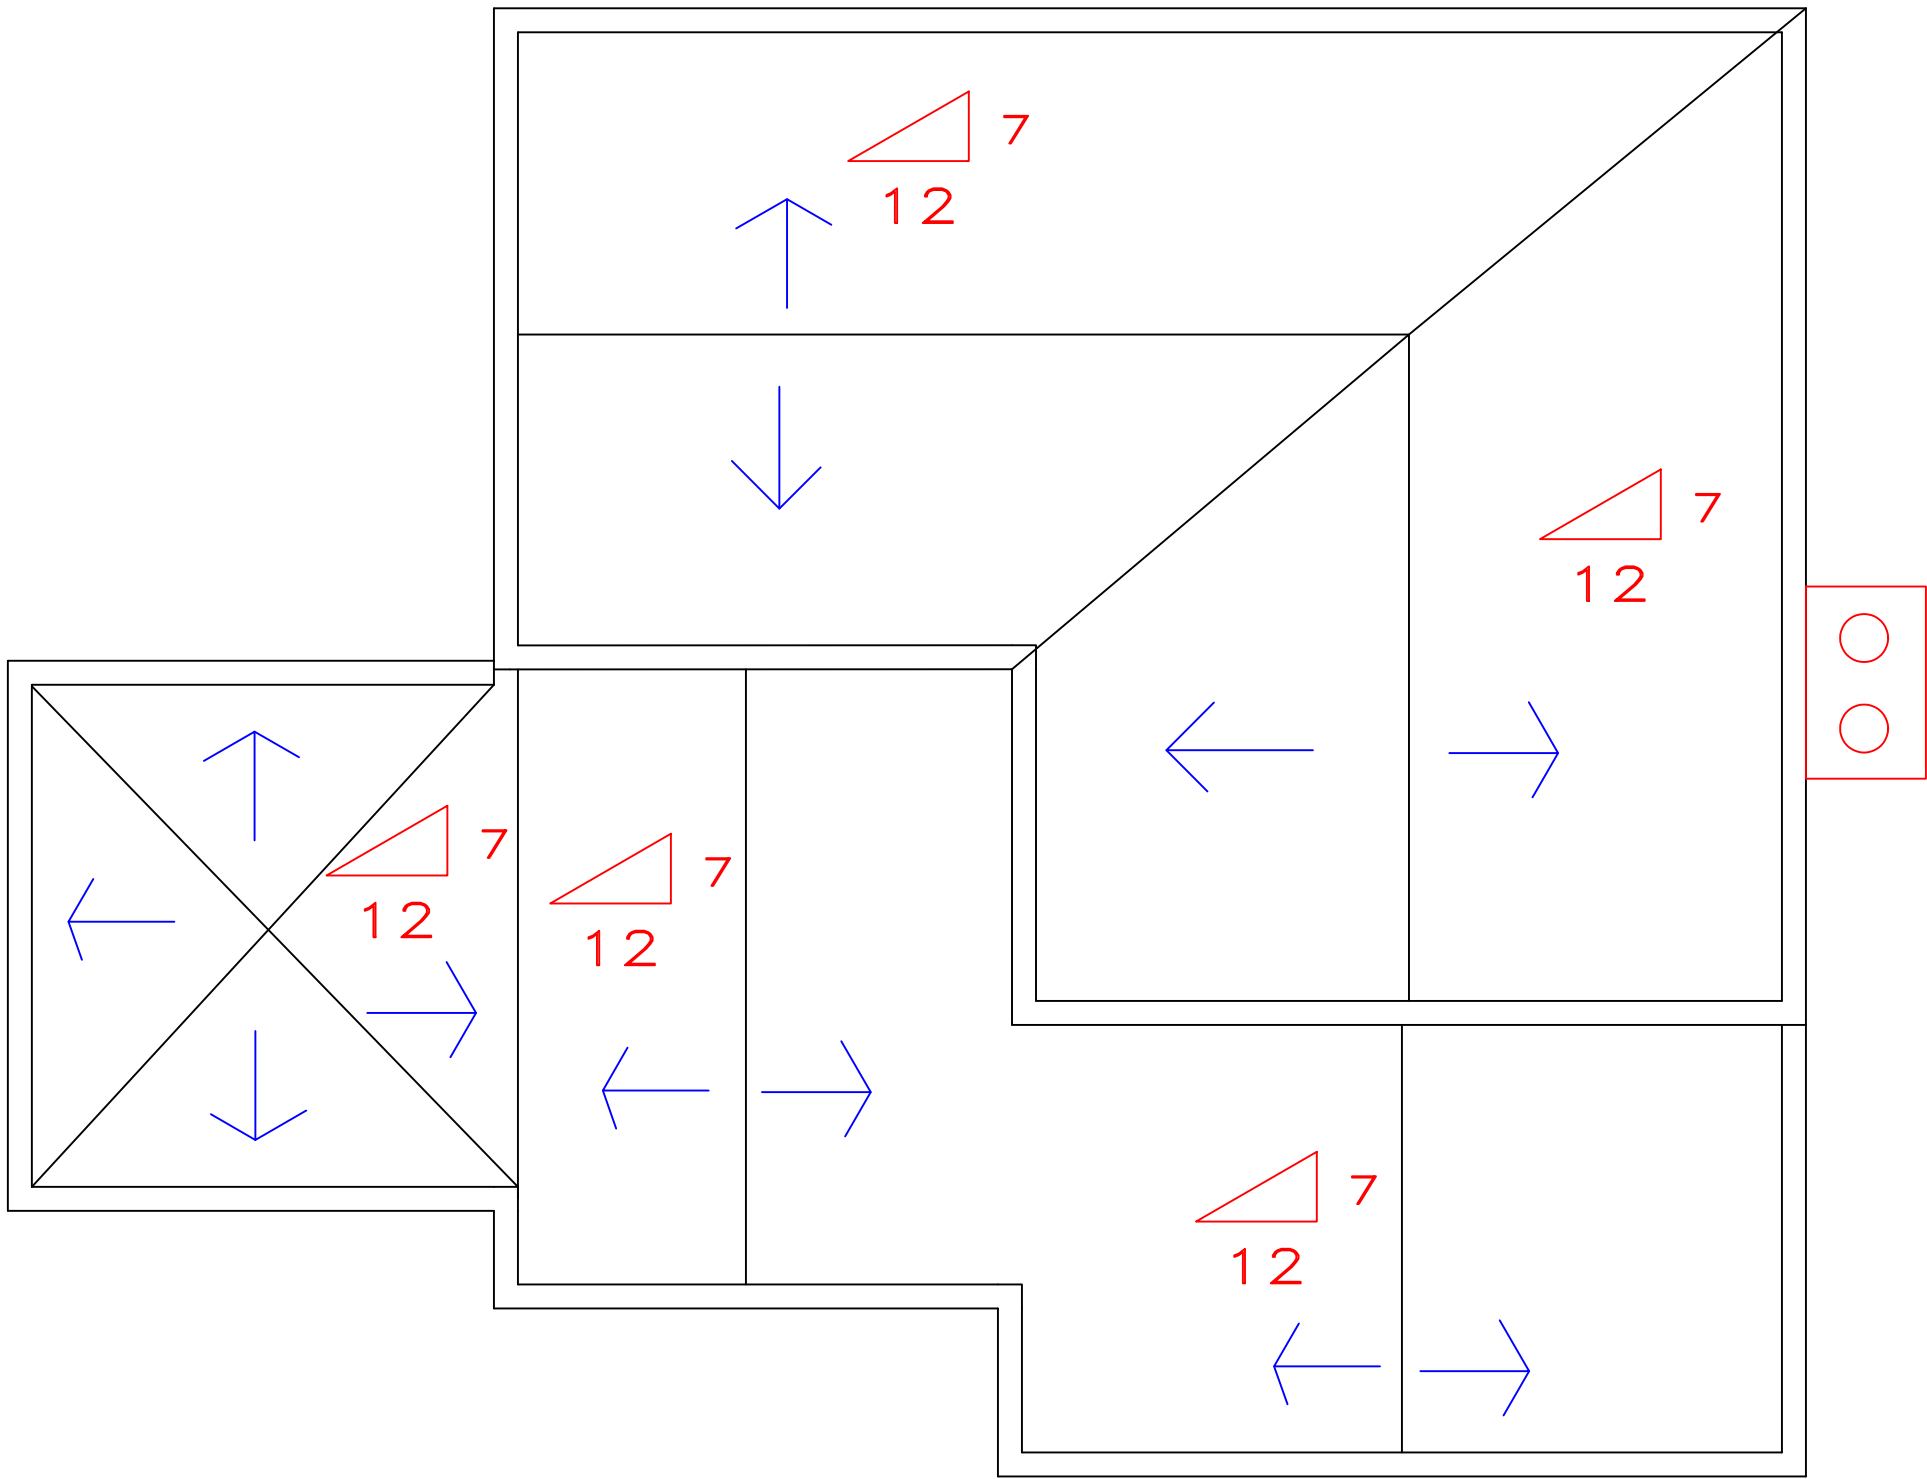

A
013

ROOF PLAN

SCALE 1/4"=1'-0"

SHEET TITLE


ROSANN ROMANO

PROJECT 1

SCALE 1/4

DRAWING

REF: _____
PROJECT NO: _____
DATE: _____
FILE: SITE_PLAN PROJ 1A
CONSTRUCTION
DESIGN 3.20.17.DWG
DRAWN BY: _____
CHK'D BY: _____

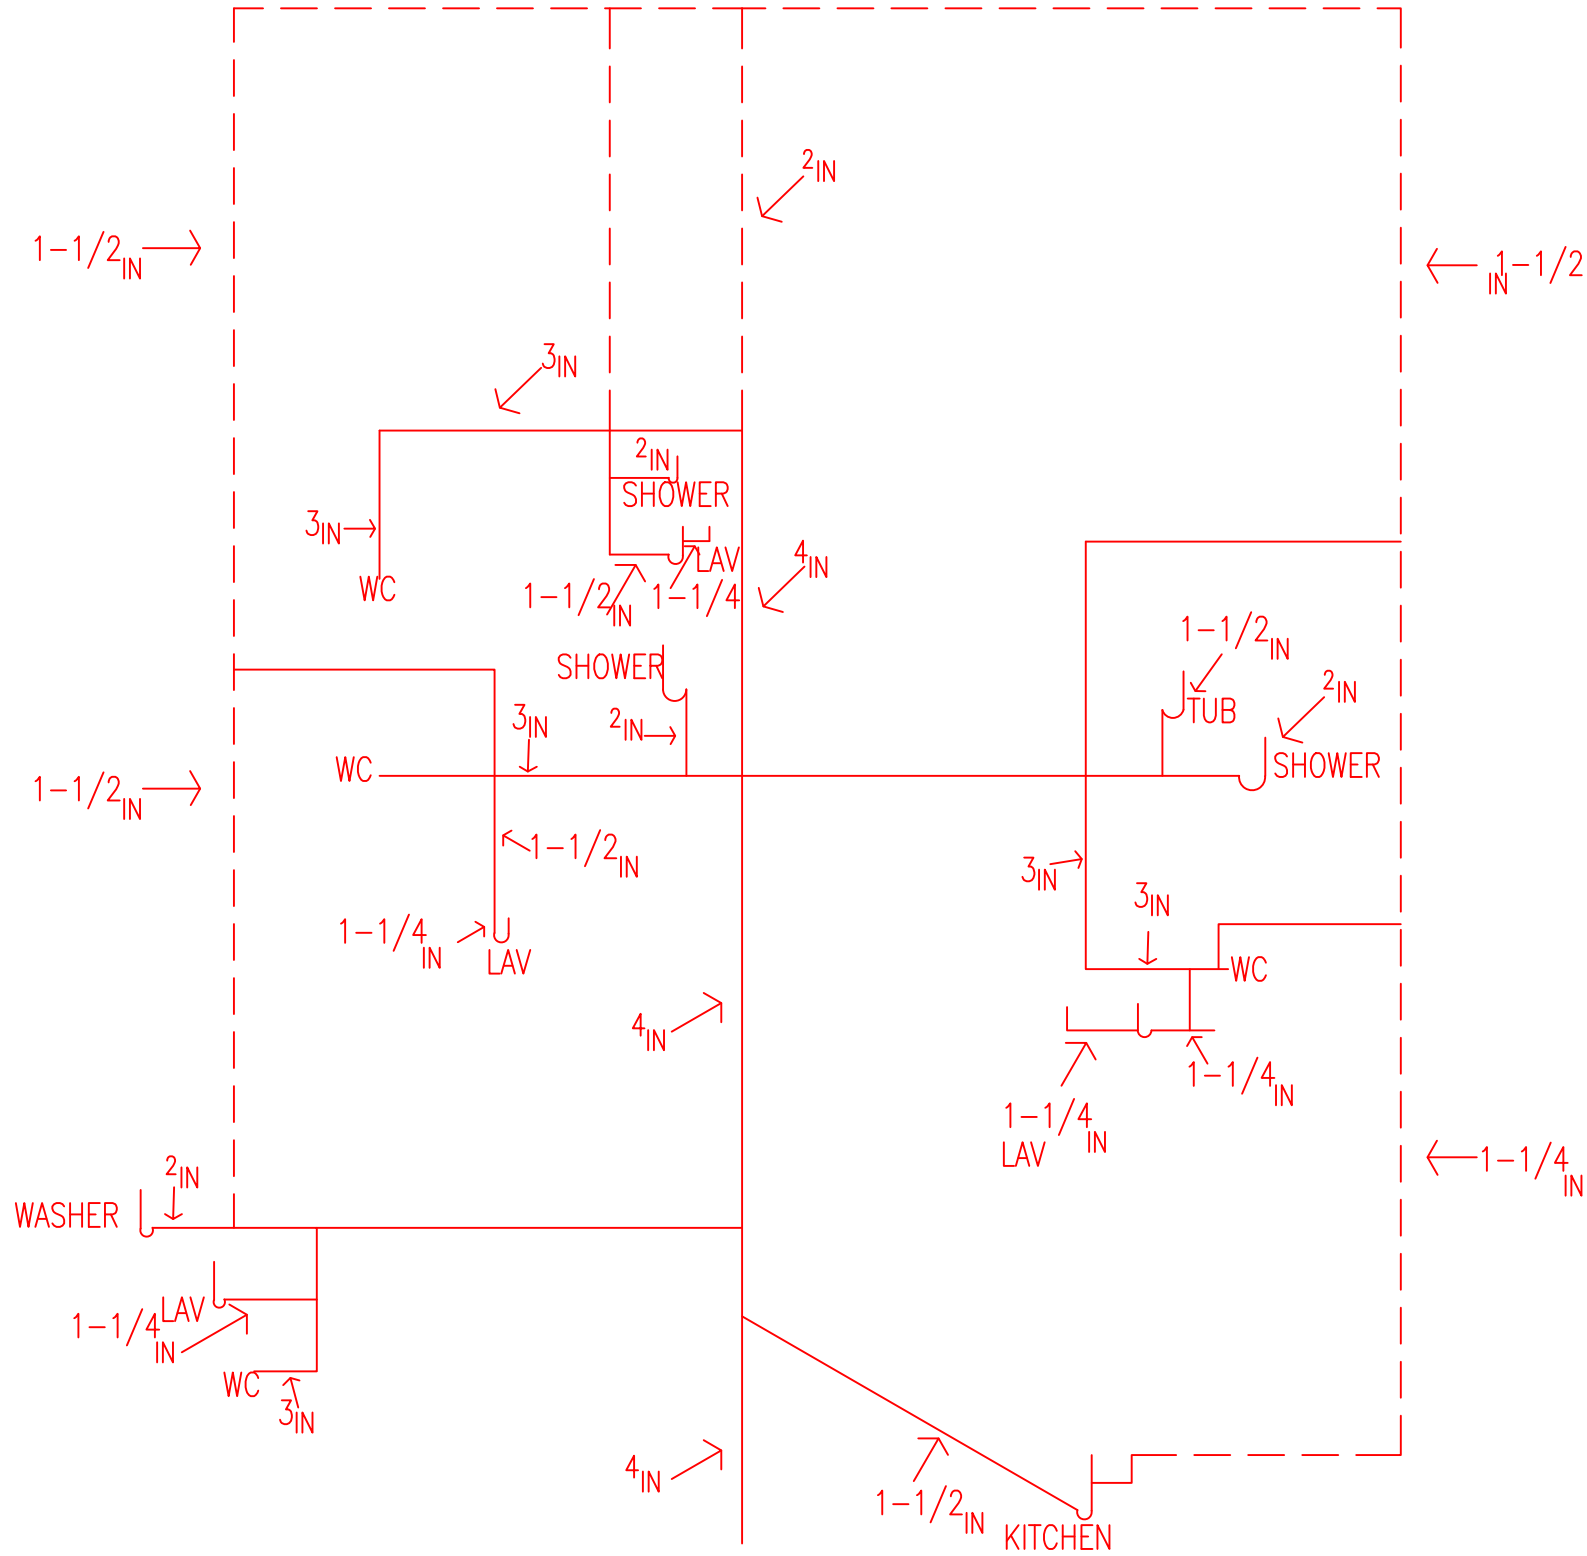

A
006

PLUMBING PLAN

SCALE 1/4"=1'-0"

SHEET TITLE


ROSANN ROMANO

PROJECT 1

SCALE 1/4

DRAWING

REF: _____
PROJECT NO: _____
DATE: _____
FILE: SITE_PLAN PROJ 1A
CONSTRUCTION
DESIGN 3.20.17.DWG
DRAWN BY: _____
CHK'D BY: _____

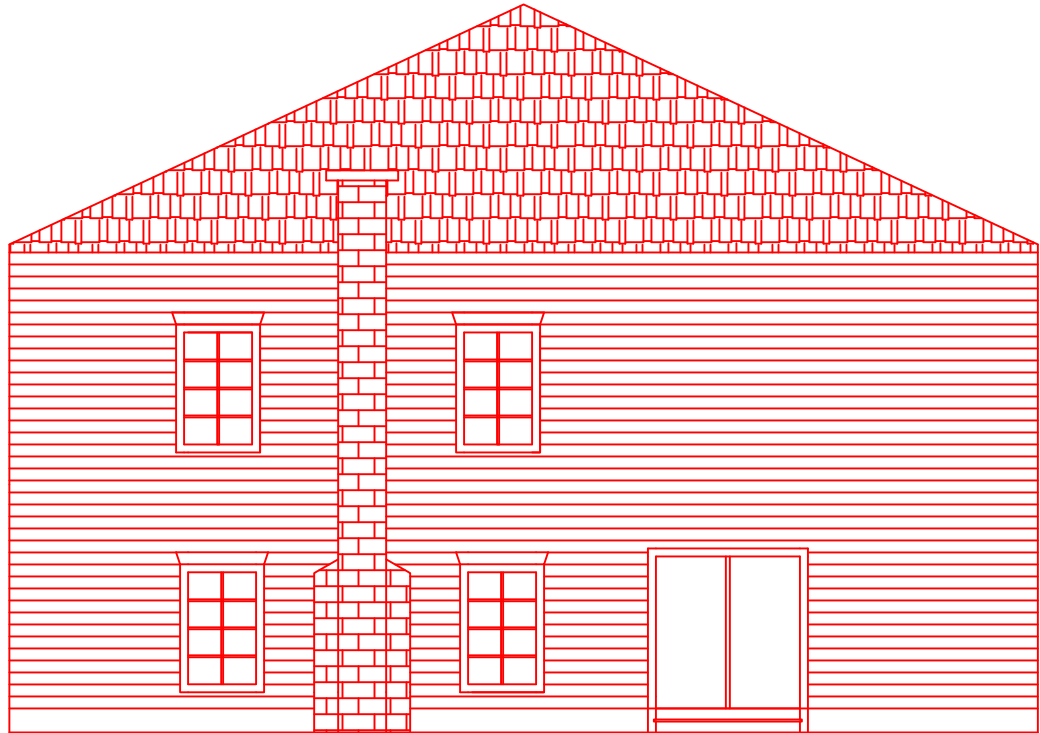

A
010

WEST ELEVATION

SCALE 1/4"=1'-0"

SHEET TITLE

ROSANN ROMANO

PROJECT 1

SCALE 1/4

DRAWING

REF:

PROJECT NO: _____

DATE:


FILE: SITE_PLAN PROJ 1A

CONSTRUCTION

DESIGN 3.20.17.DWG

DRAWN BY: 

CHK'D BY: 

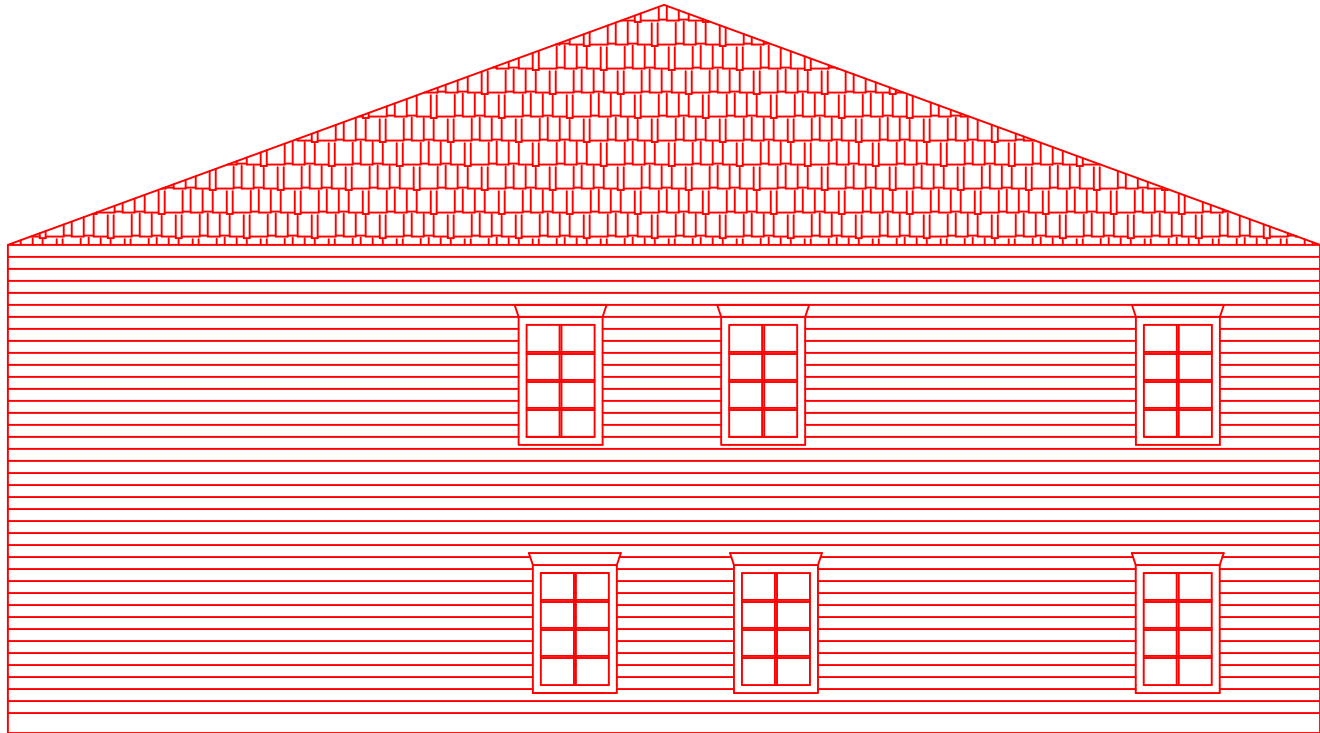

A
009

REAR ELEVATION

SCALE 1/4"=1'-0"

SHEET TITLE

ROSANN ROMANO

PROJECT 1

SCALE 1/4

DRAWING

REF:

PROJECT NO:

DATE:


FILE: SITE_PLAN PROJ 1A

CONSTRUCTION

DESIGN 3.20.17.DWG

DRAWN BY: 

CHK'D BY: 

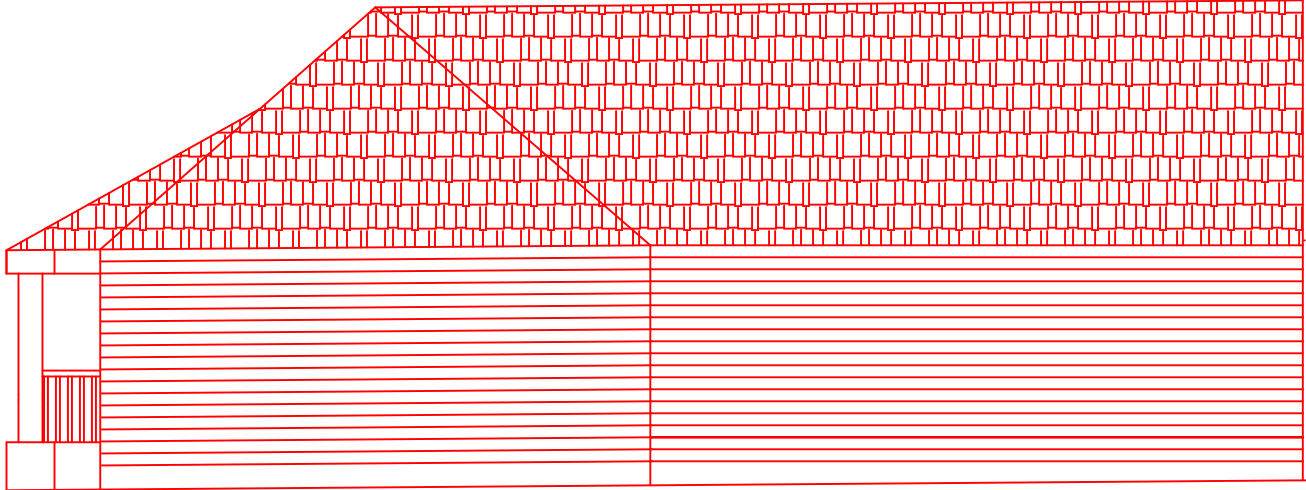

A
008

EAST ELEVATION

SCALE 1/4"=1'-0"

SHEET TITLE

ROSANN ROMANO

PROJECT 1

SCALE 1/4

DRAWING

REF:

PROJECT NO: _____

DATE:


FILE: SITE_PLAN PROJ 1A

CONSTRUCTION

DESIGN 3.20.17.DWG

DRAWN BY: 

CHK'D BY: 

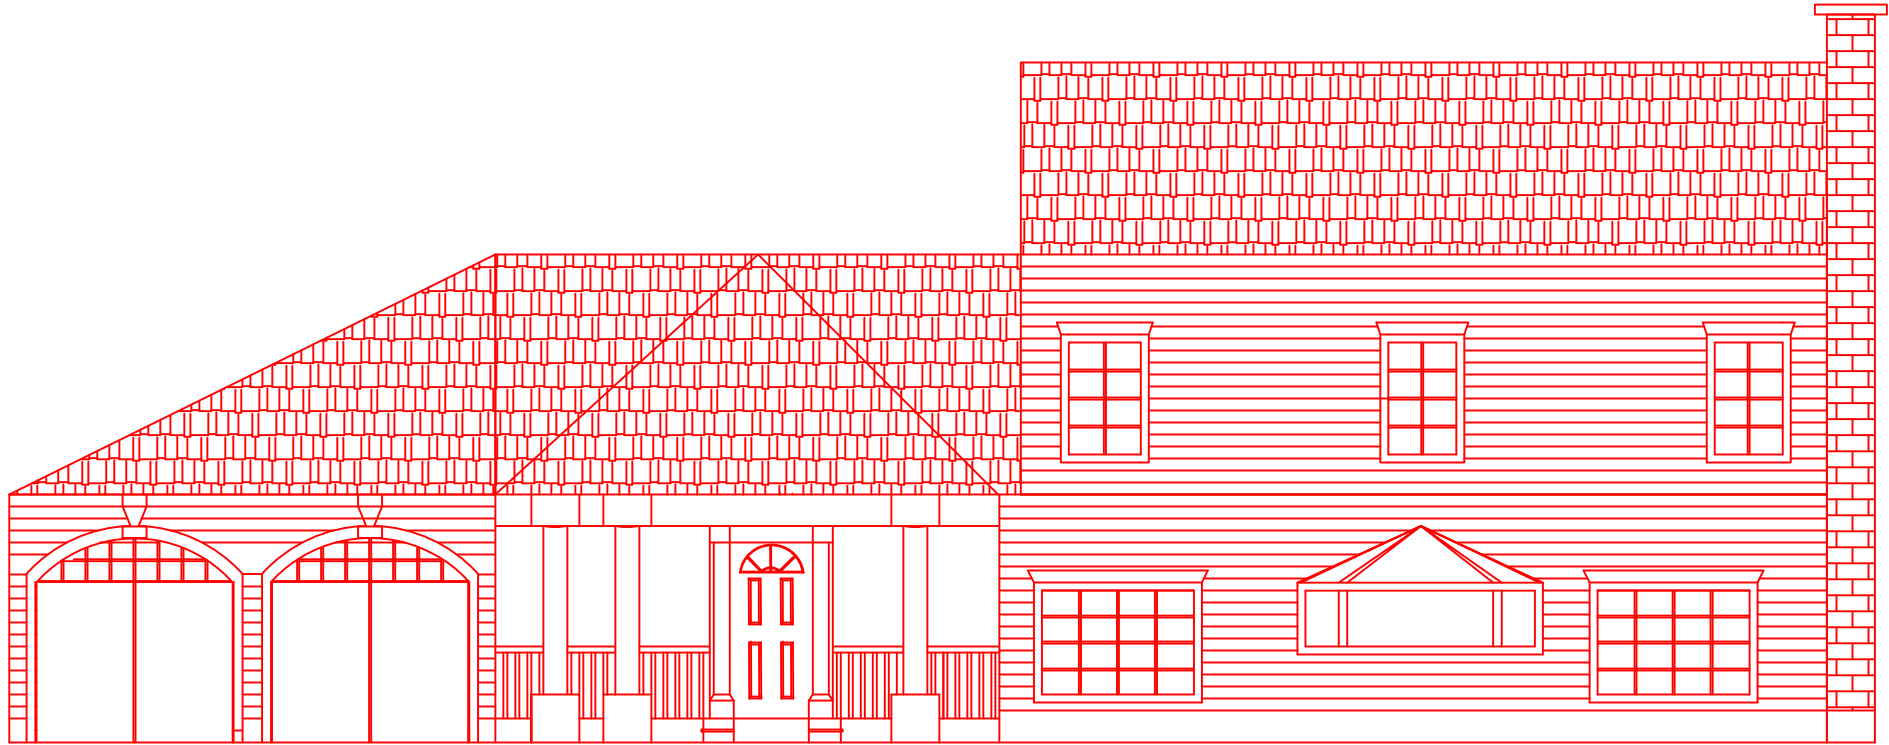

A
007

FRONT ELEVATION

SCALE 1/4"=1'-0"

SHEET TITLE


ROSANN ROMANO

PROJECT 1

SCALE 1/4

DRAWING

REF: _____
PROJECT NO: _____
DATE: _____
FILE: SITE PLAN PROJ 1A
CONSTRUCTION
DESIGN 3.20.17.DWG
DRAWN BY: _____
CHK'D BY: _____

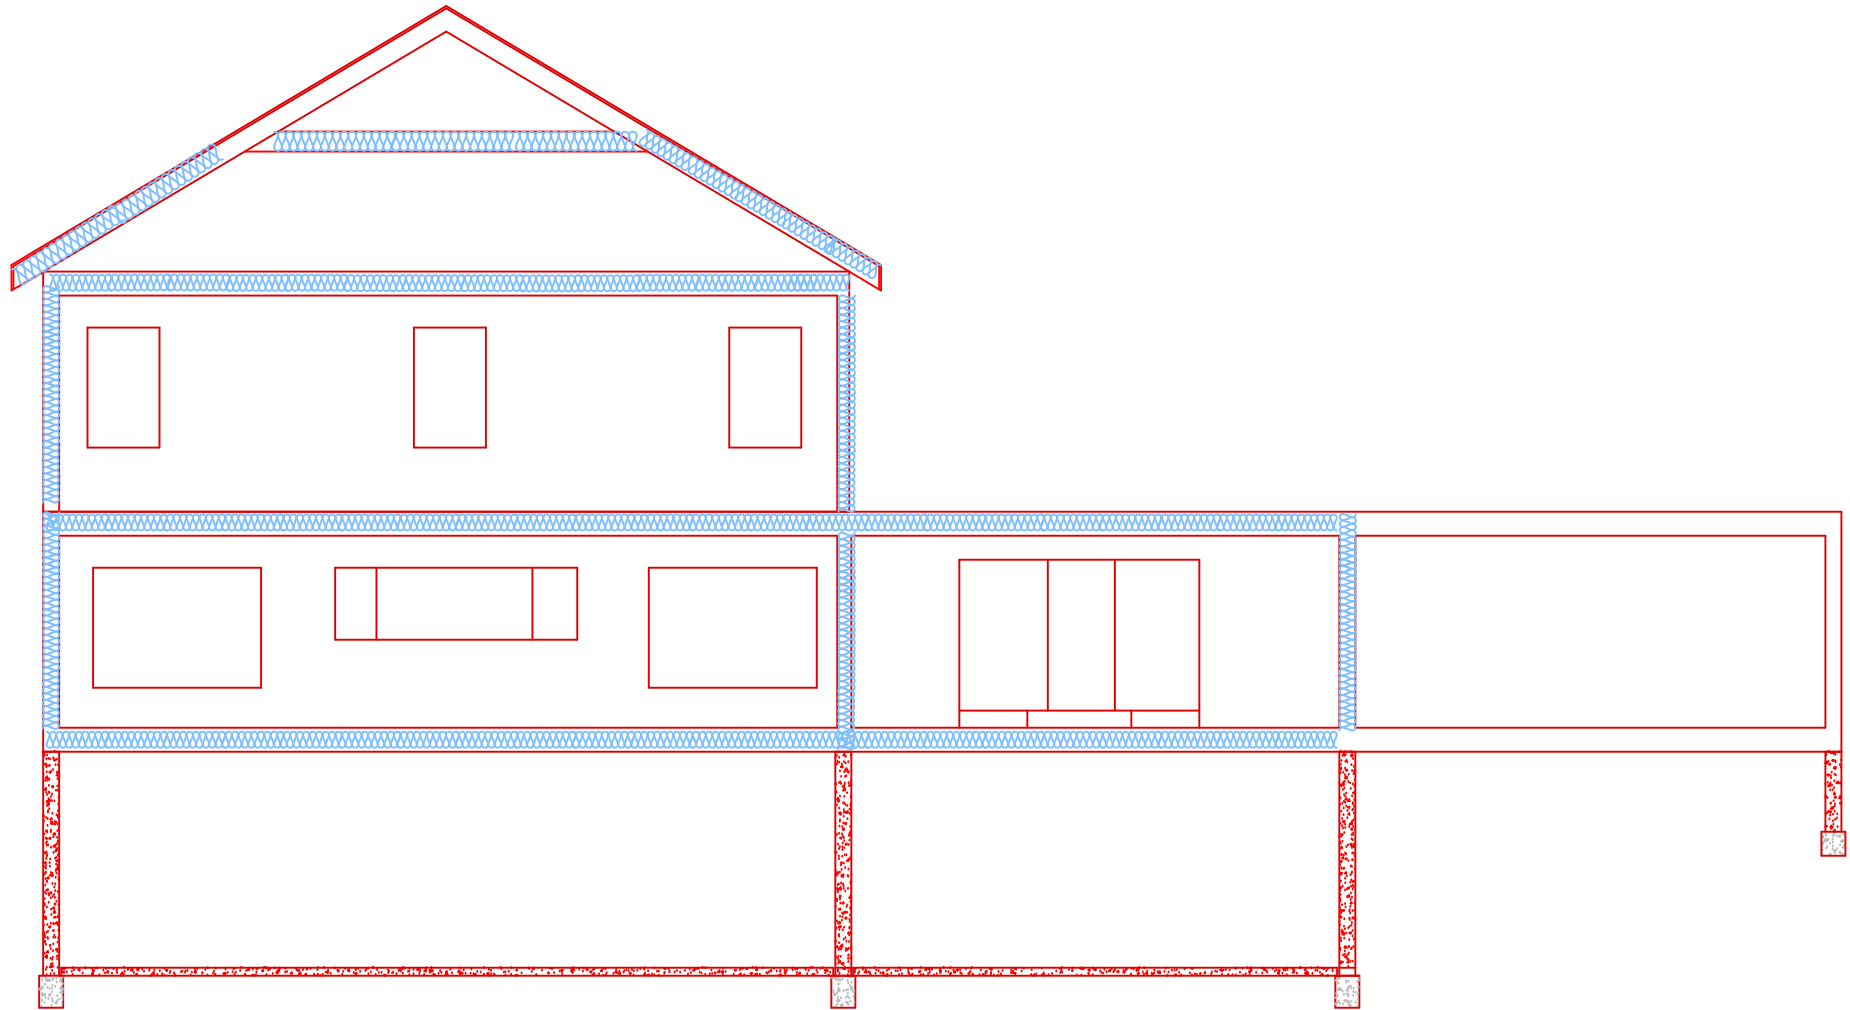

A
011

SECTION 1

SCALE 1/4"=1'-0"

SHEET TITLE


ROSANN ROMANO

PROJECT 1

SCALE 1/4

DRAWING

REF:
PROJECT NO:
DATE:
FILE: SITE PLAN PROJ 1A
CONSTRUCTION
DESIGN 3.20.17.DWG
DRAWN BY:
CHK'D BY:

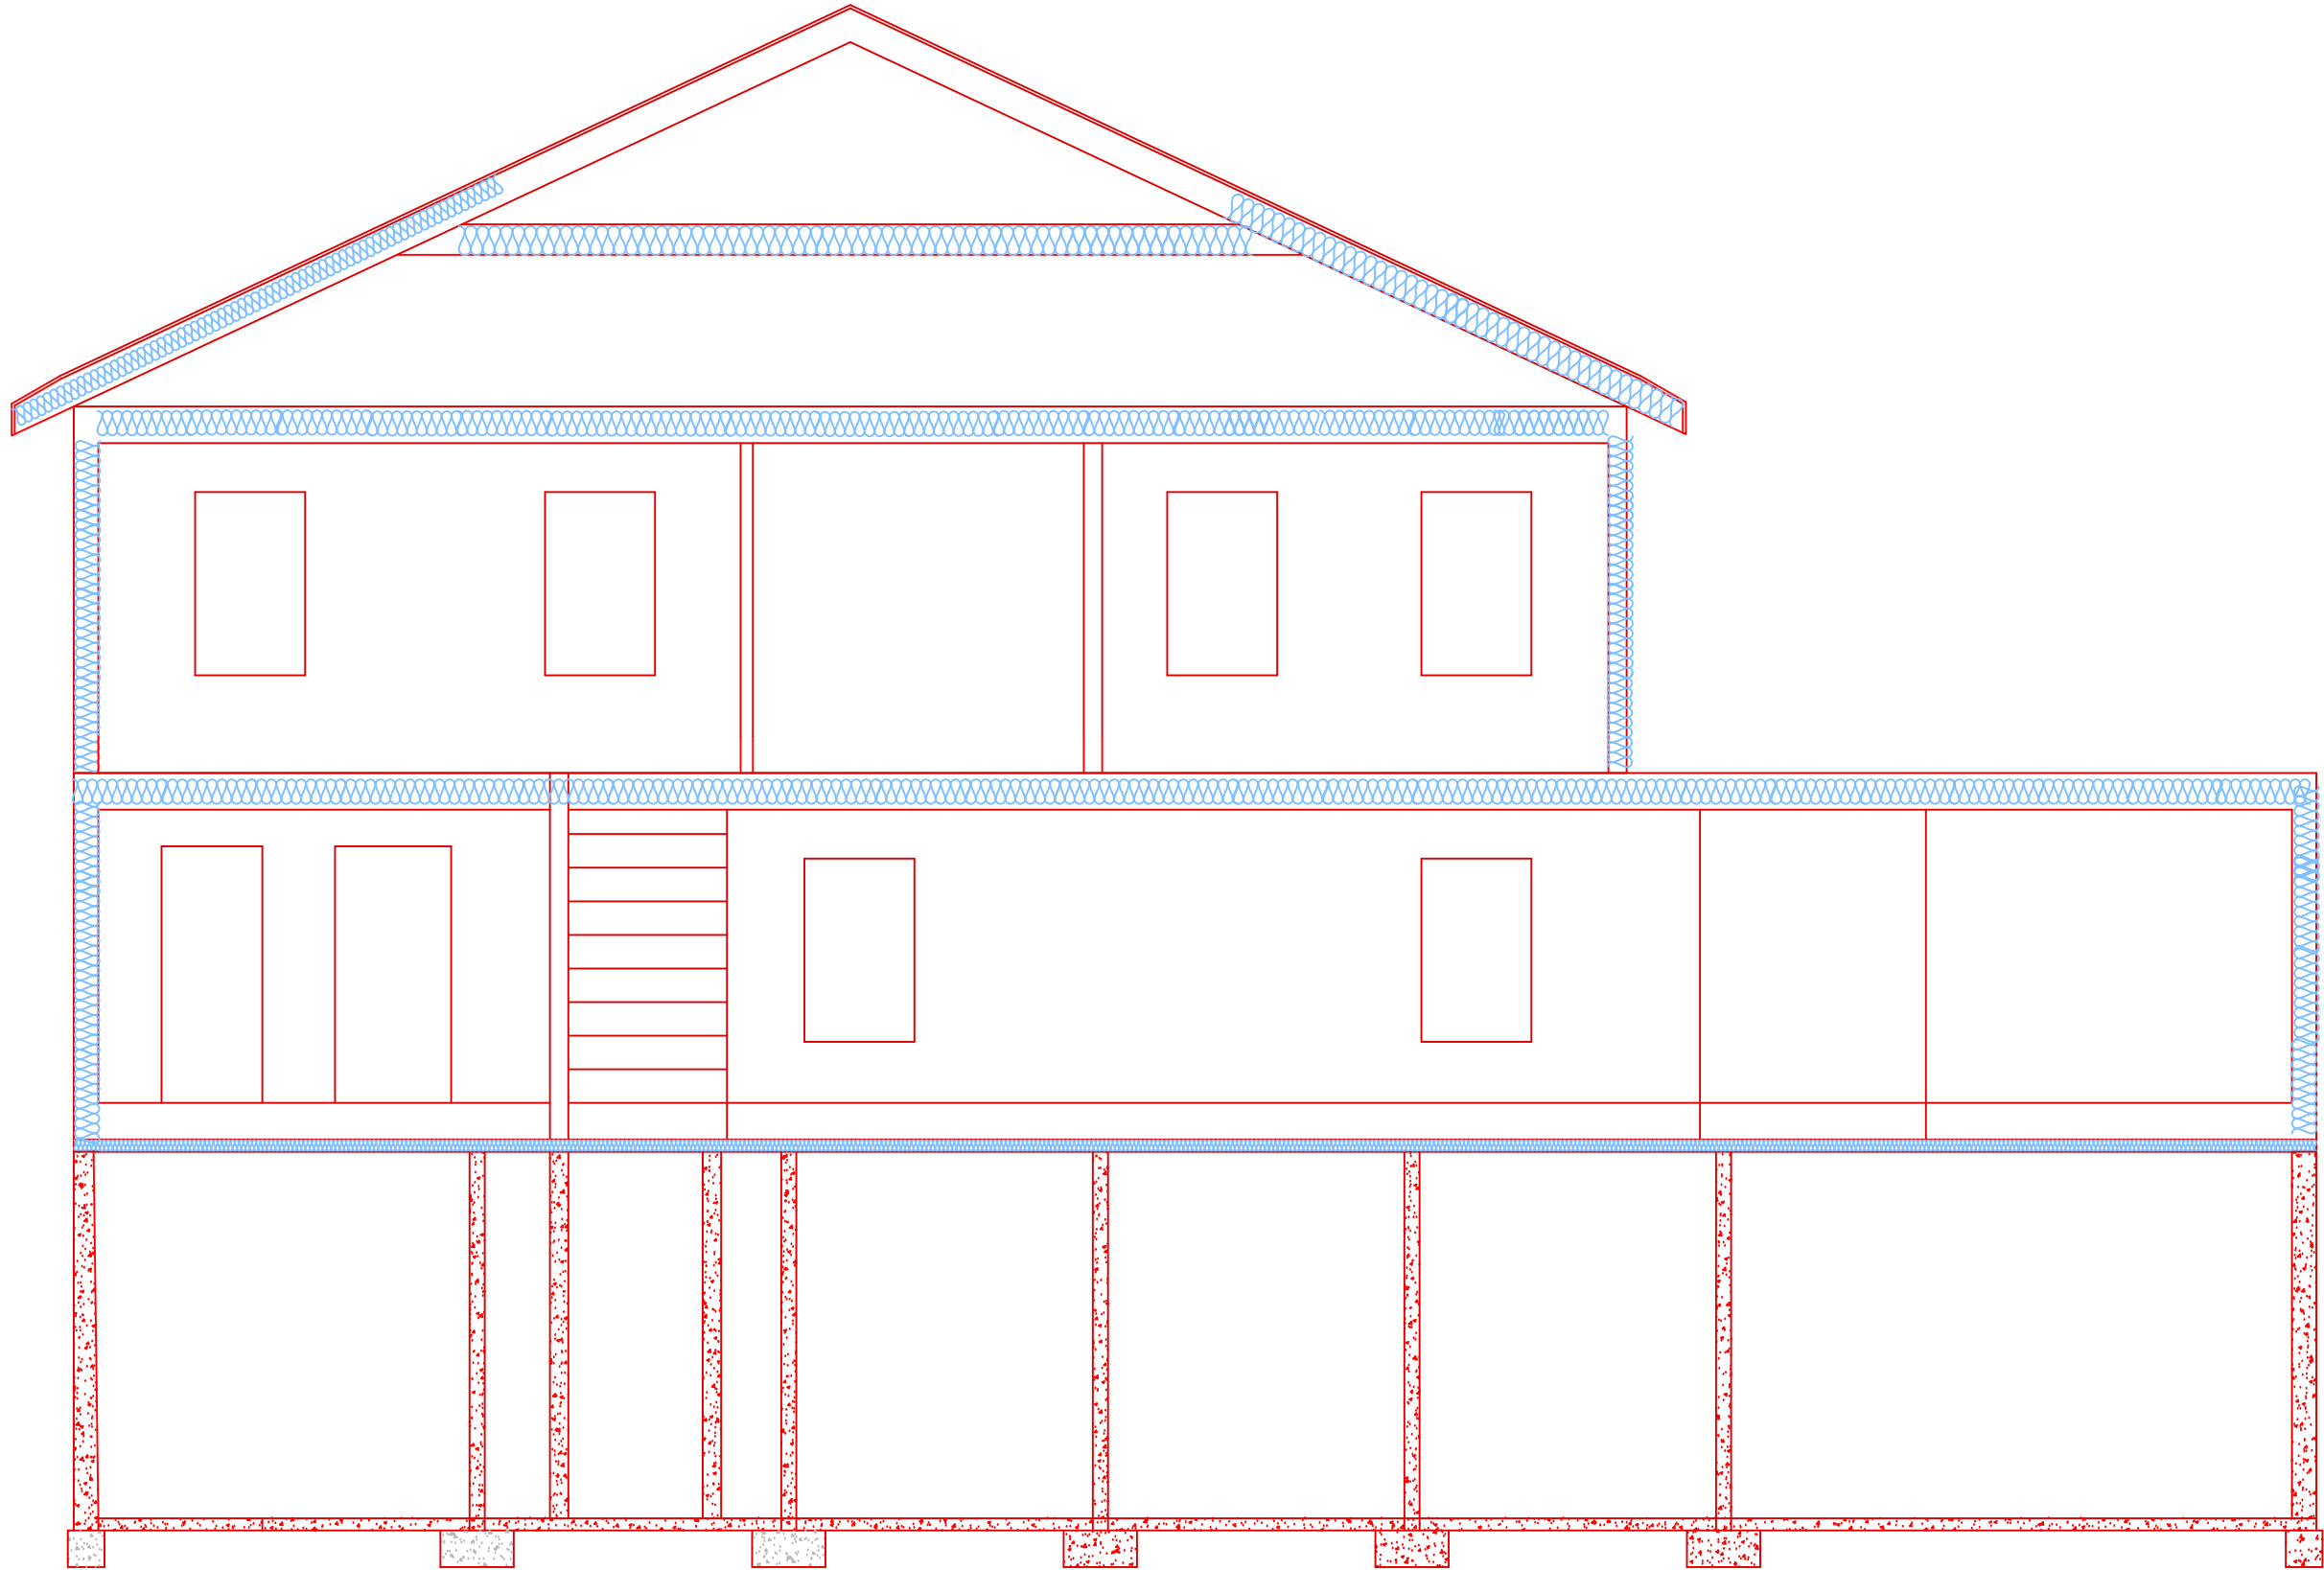

A
012

SECTION 2

SCALE 1/4"=1'-0"

SHEET TITLE

ROSANN ROMANO

PROJECT 1


SCALE 1/4

DRAWING

REF: _____
PROJECT NO: _____
DATE: _____
FILE: SITE PLAN PROJ 1A
CONSTRUCTION
DESIGN 3.20.17.DWG
DRAWN BY: 
CHK'D BY: 

A
003

FOUNDATION PLAN
SCALE 1/4"=1'-0"

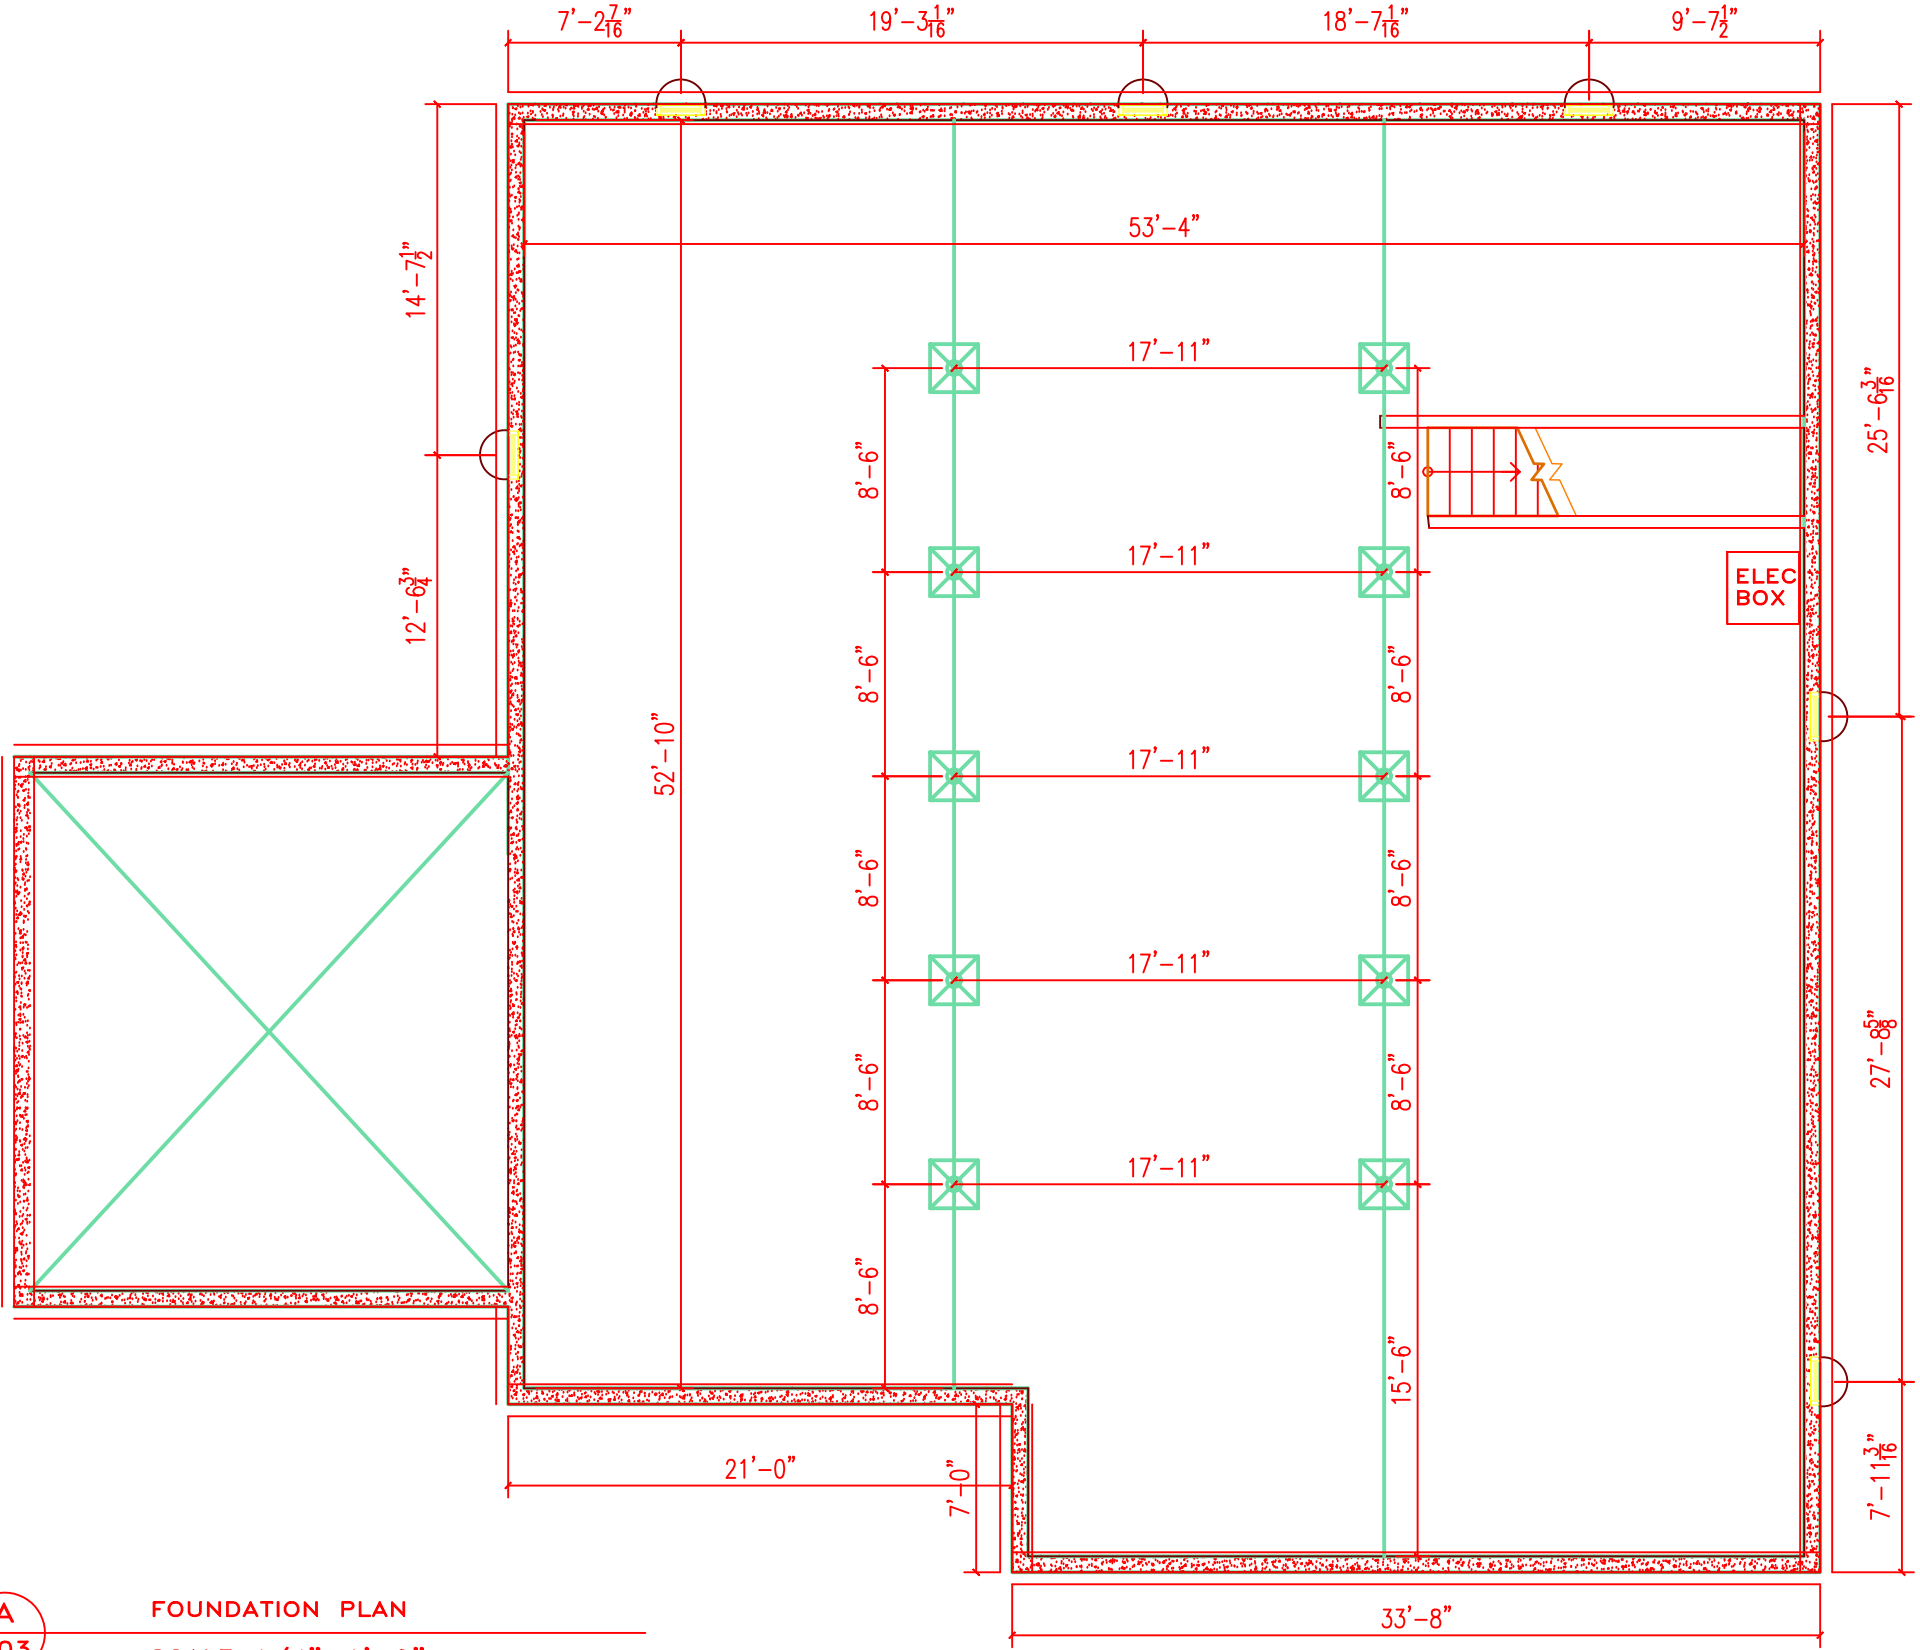

SHEET TITLE

ROSANN ROMANO

PROJECT 1

SCALE 1/4


REF: _____
PROJECT NO: _____
DATE: _____
FILE: SITE_PLAN PROJ 1A
CONSTRUCTION
DESIGN 3.20.17.DWG
DRAWN BY: _____
CHK'D BY: _____

DRAWING

A
002

SECOND FLOOR PLAN

SCALE 1/4"=1'-0"

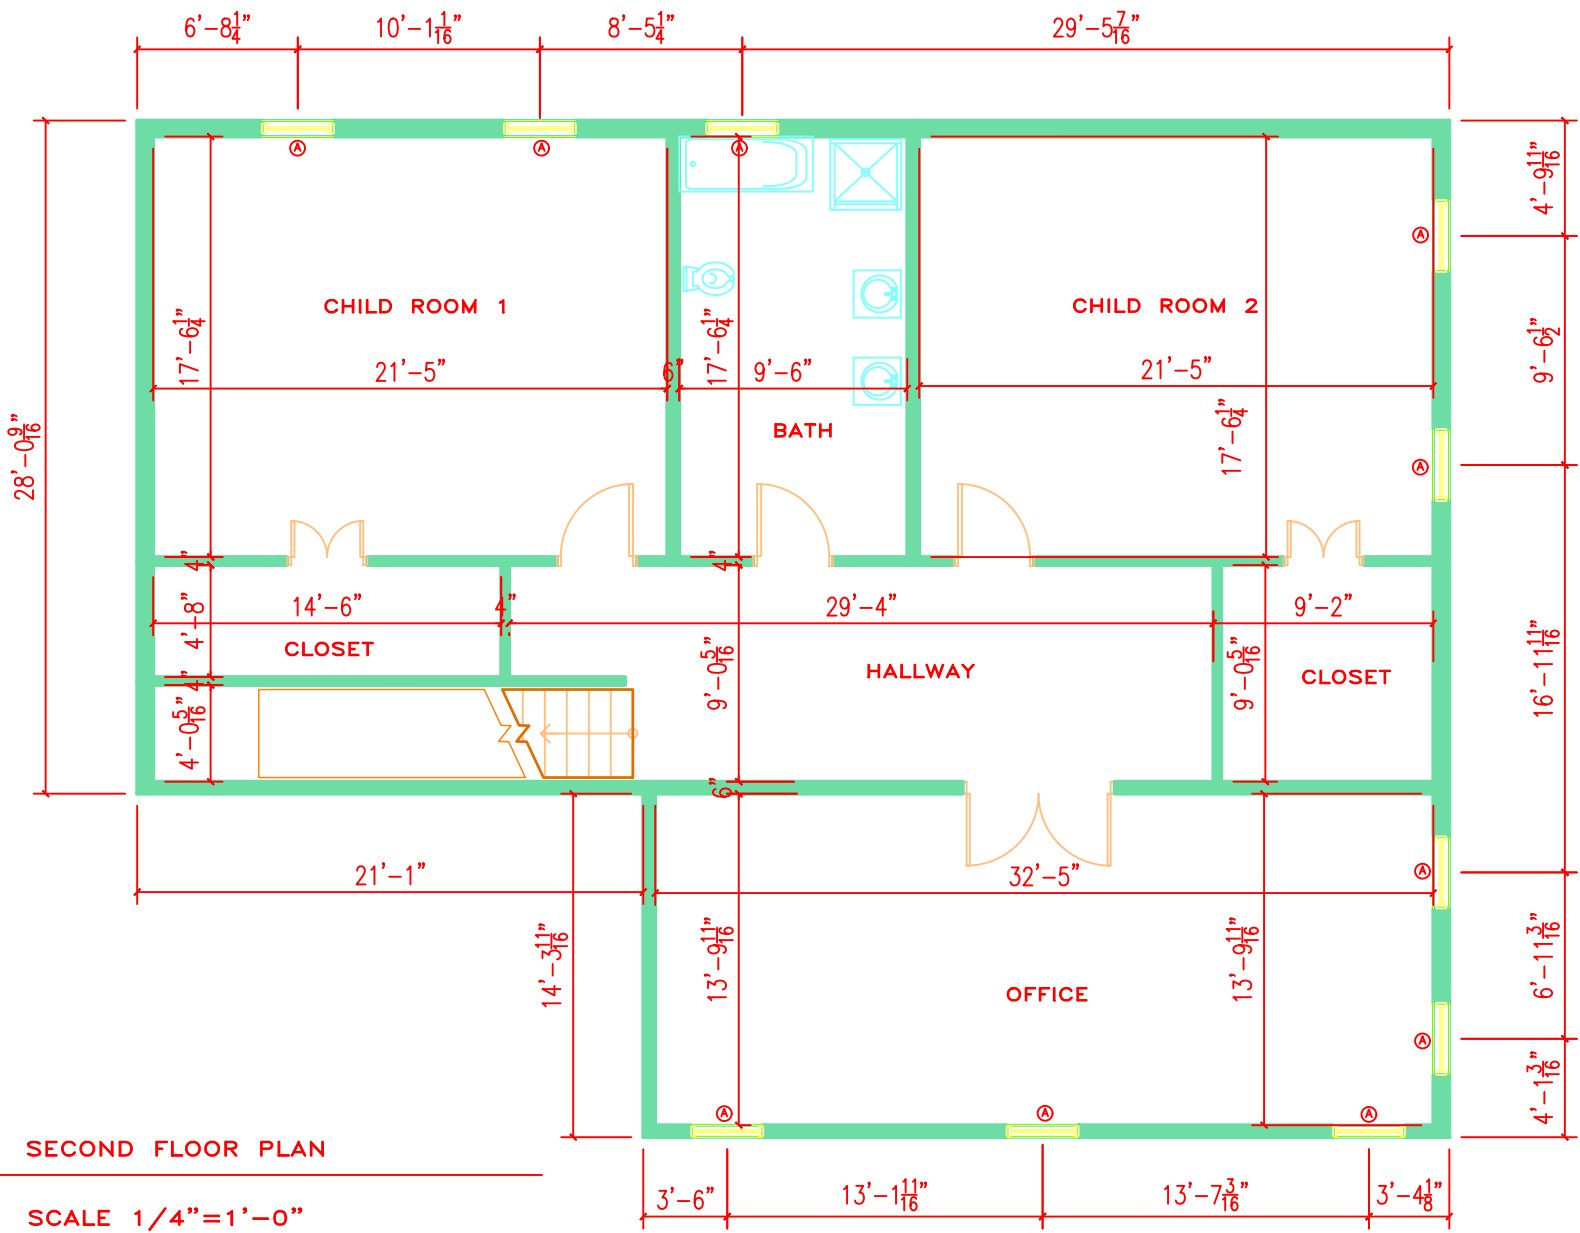

SHEET TITLE


ROSANN ROMANO

PROJECT 1

SCALE 1/4

REF: _____
PROJECT NO: _____
DATE: _____
FILE: SITE_PLAN PROJ 1A
CONSTRUCTION
DESIGN 3.20.17.DWG
DRAWN BY: _____
CHK'D BY: _____

DRAWING

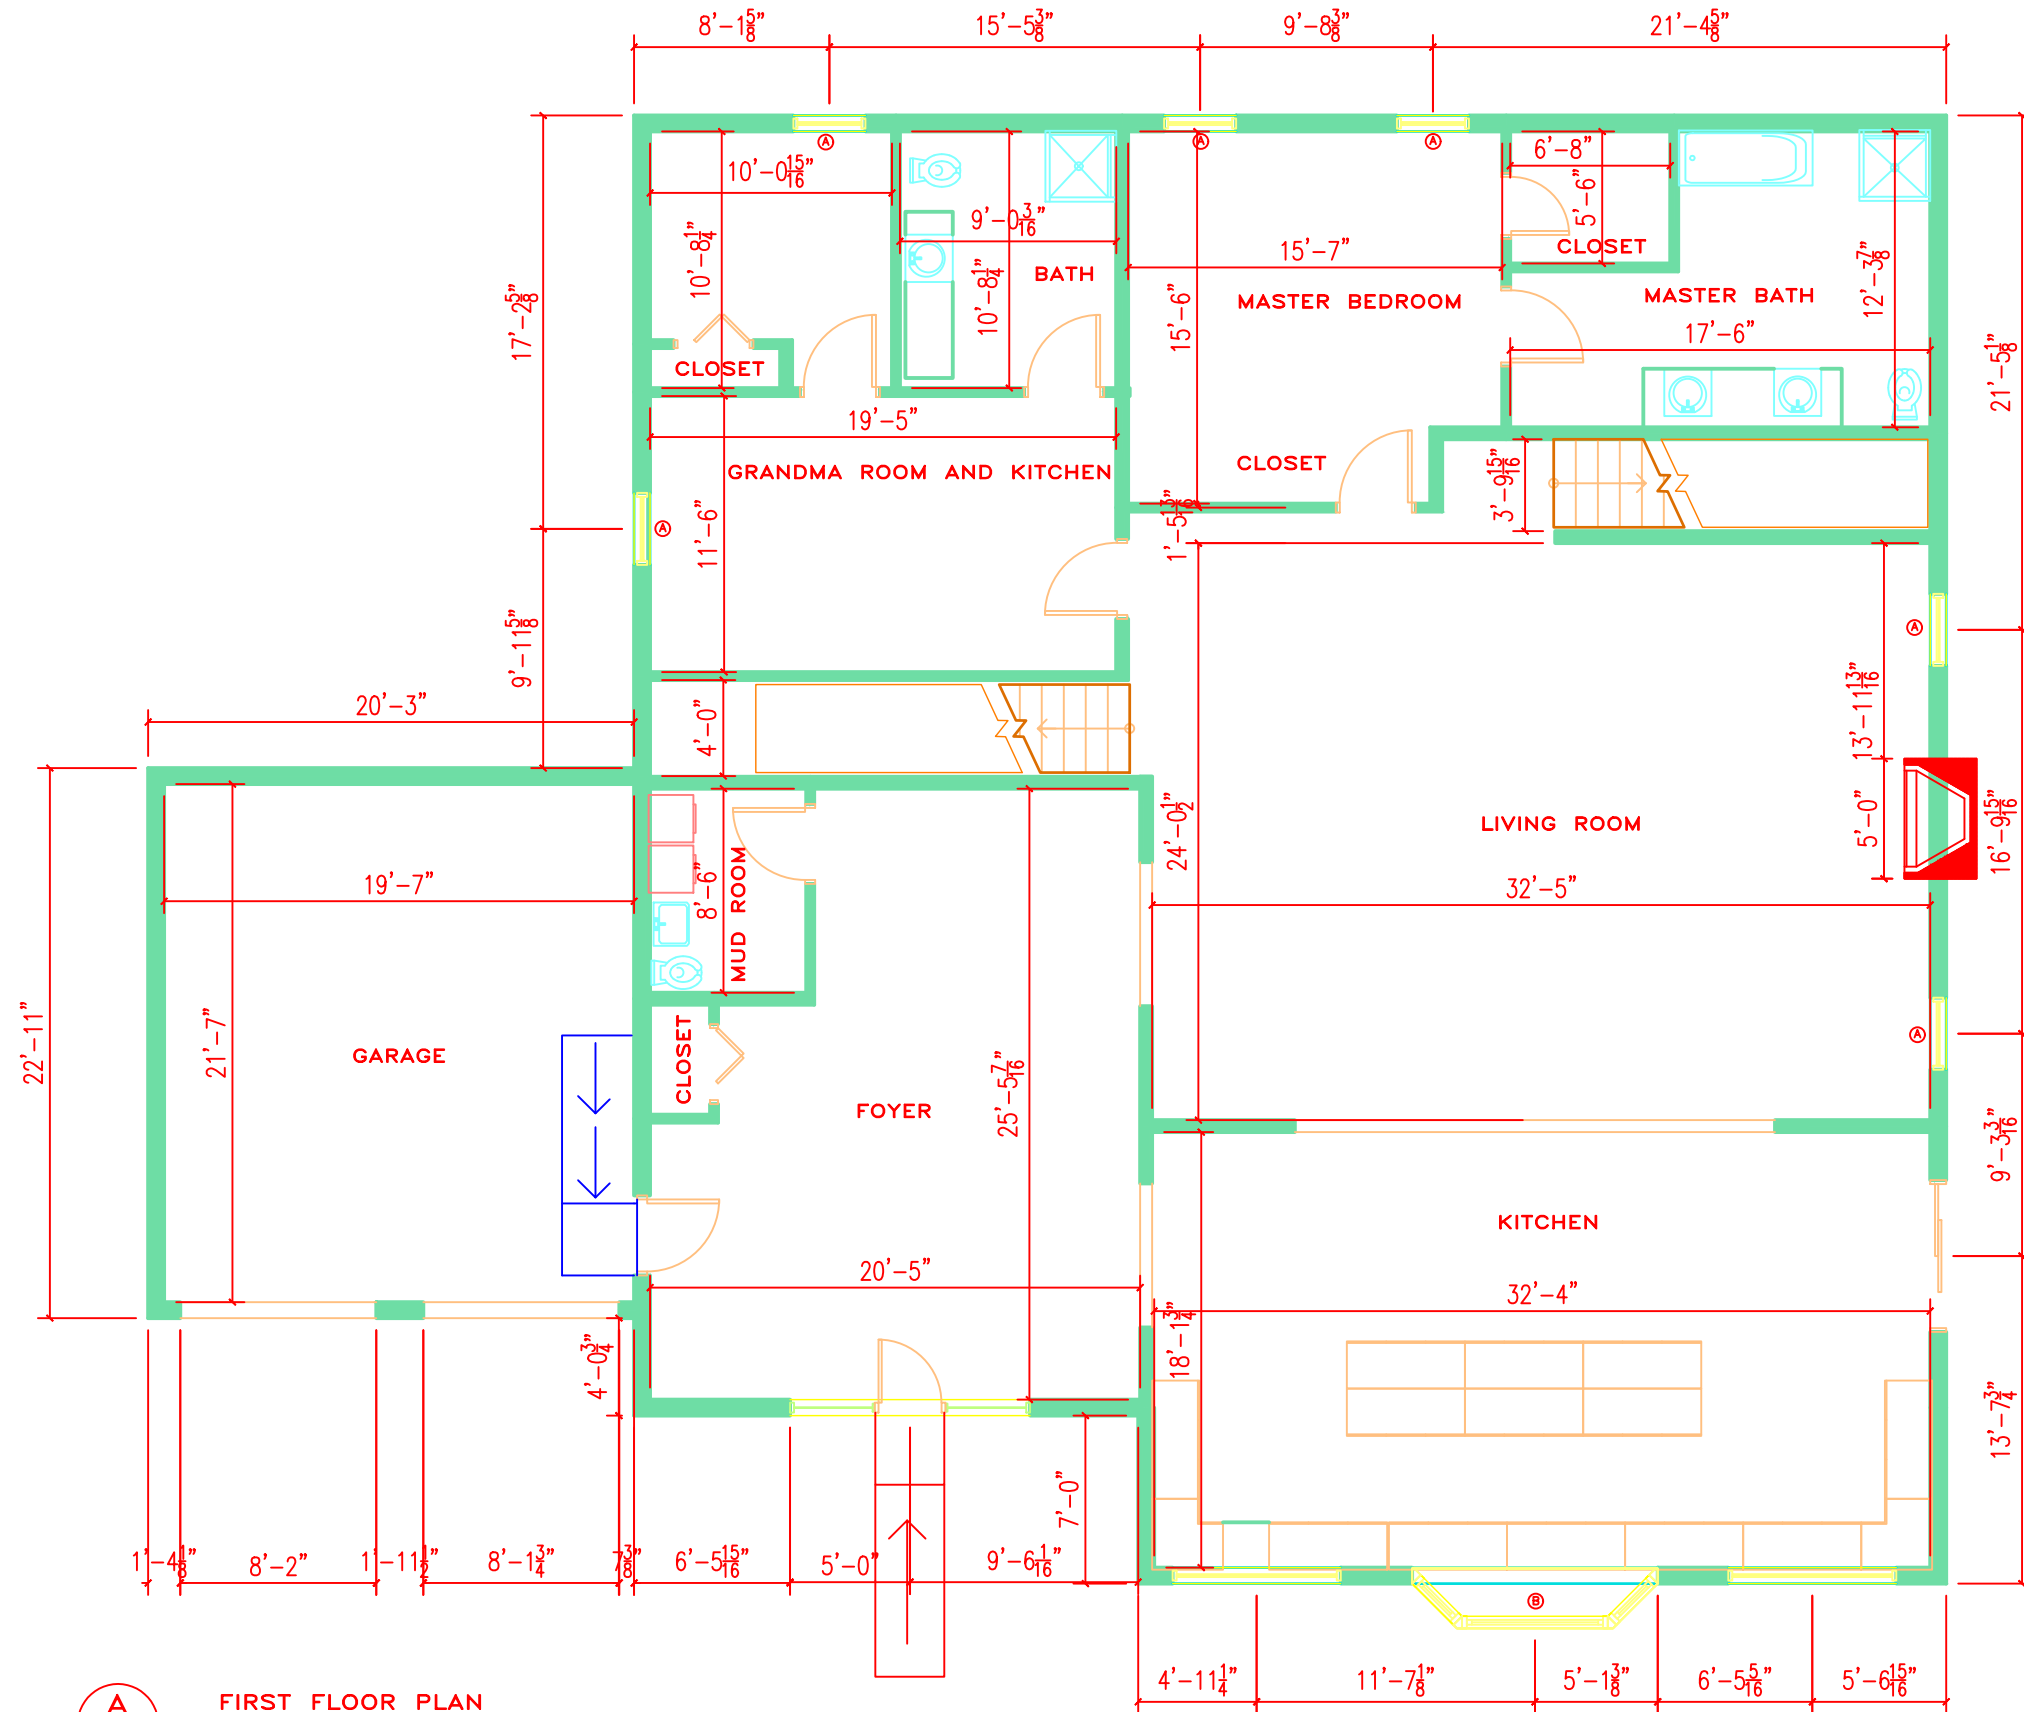

A
001

FIRST FLOOR PLAN

SCALE 1/4"=1'-0"

SHEET TITLE


ROSANN ROMANO

PROJECT 1

SCALE 1/4

REF:	PROJECT NO:
DATE:	FILE: SITE PLAN PROJ 1A
	CONSTRUCTION
	DESIGN 3.20.17.DWG
DRAWN BY:	CHK'D BY:

DRAWING

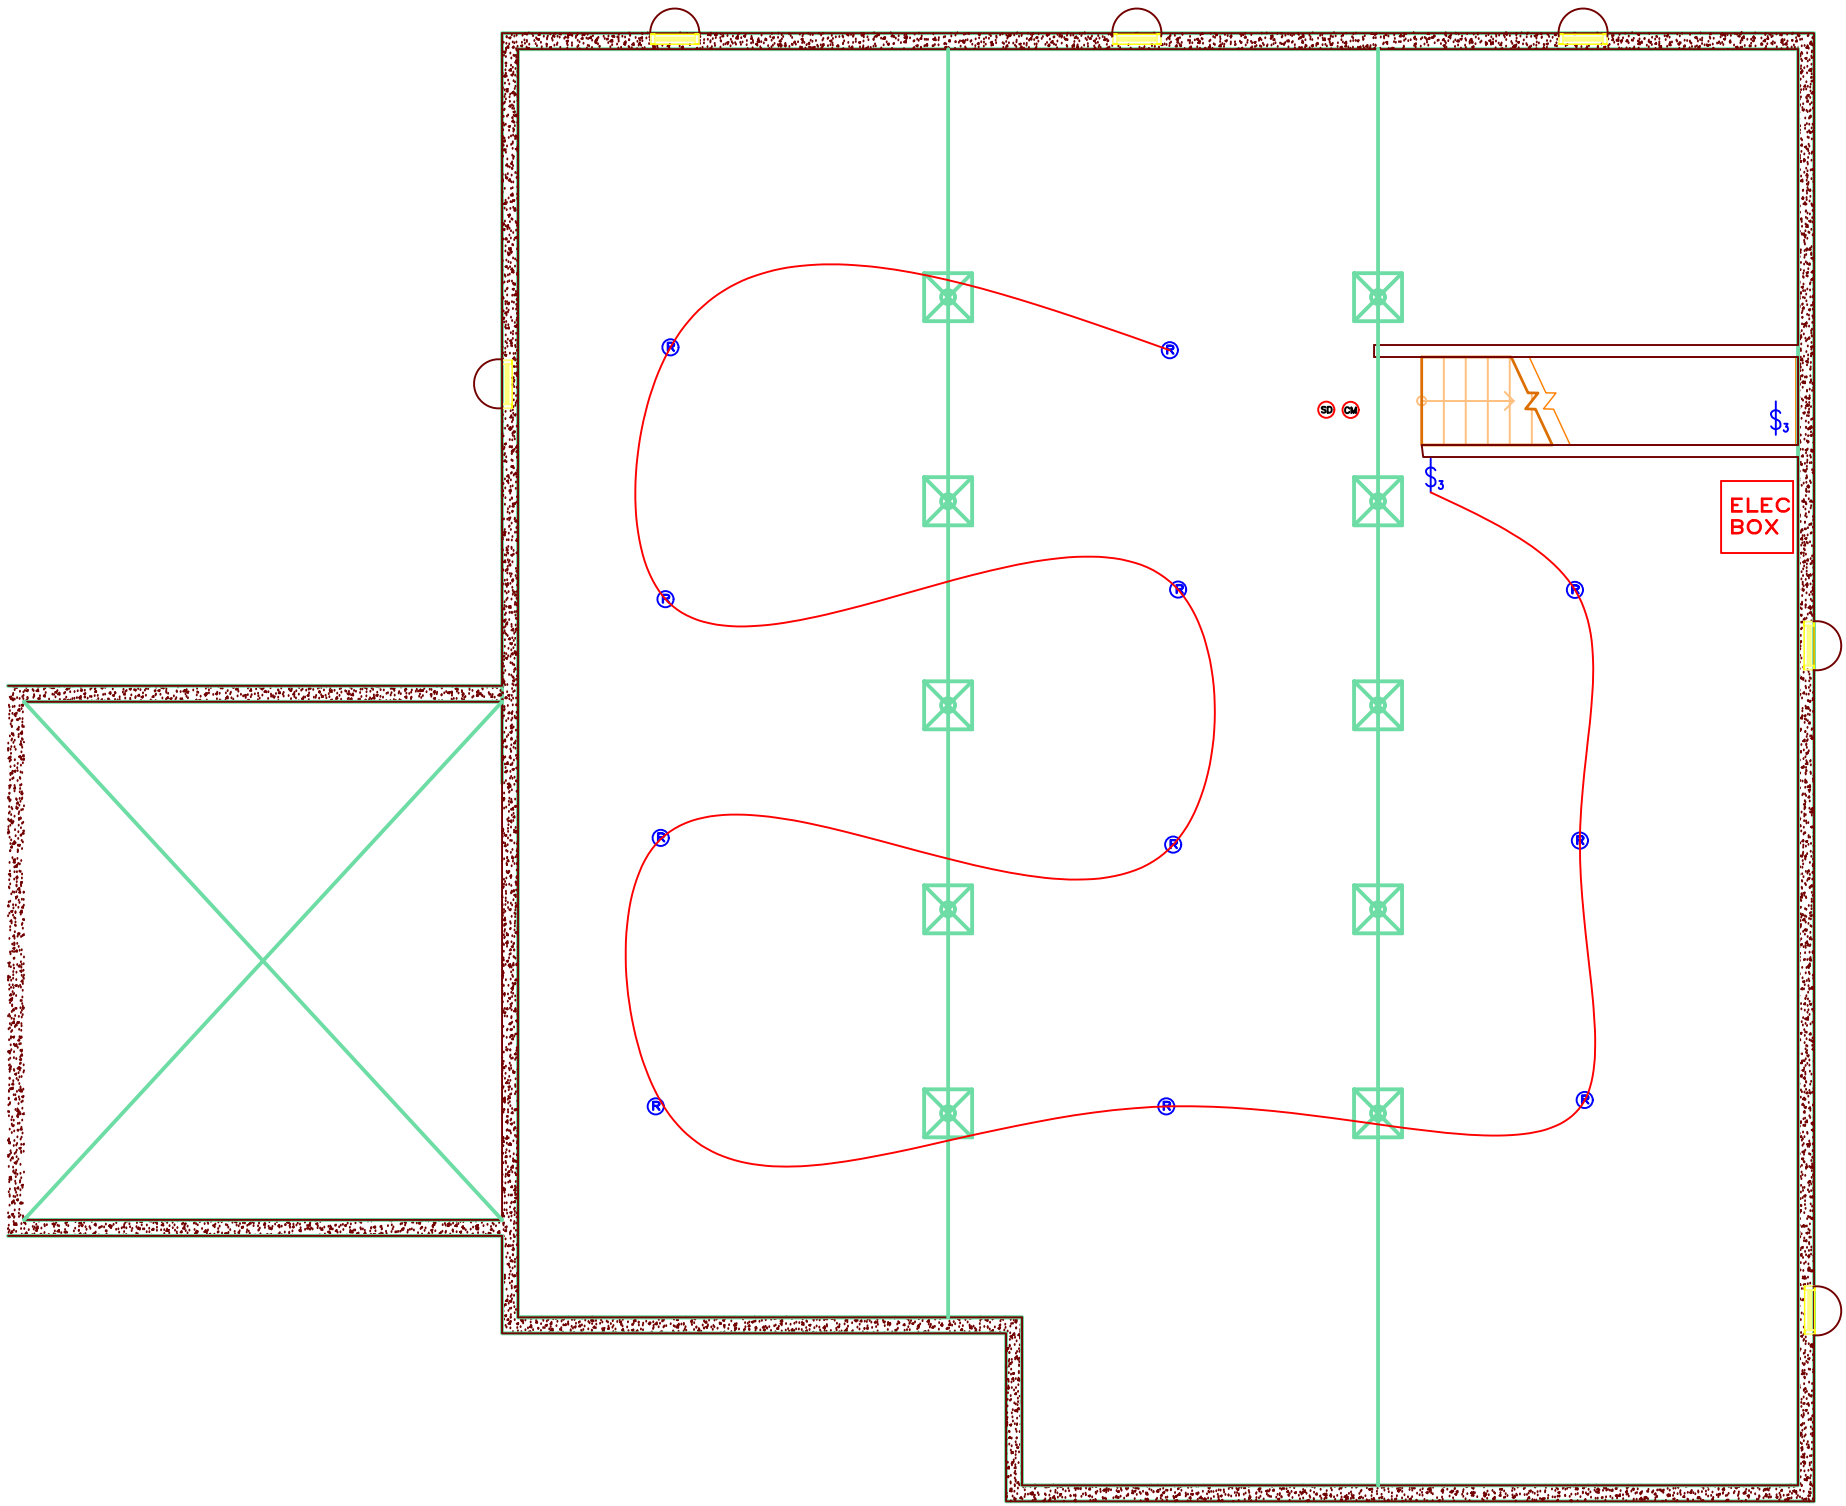

A
006

BASEMENT ELECTRICAL PLAN

SCALE 1/4"=1'-0"

SHEET TITLE


ROSANN ROMANO

PROJECT 1

SCALE 1/4

REF:
PROJECT NO: ---
DATE:
FILE: SITE_PLAN PROJ 1A
CONSTRUCTION
DESIGN 3.20.17.DWG
DRAWN BY: 
CHK'D BY: 

DRAWING

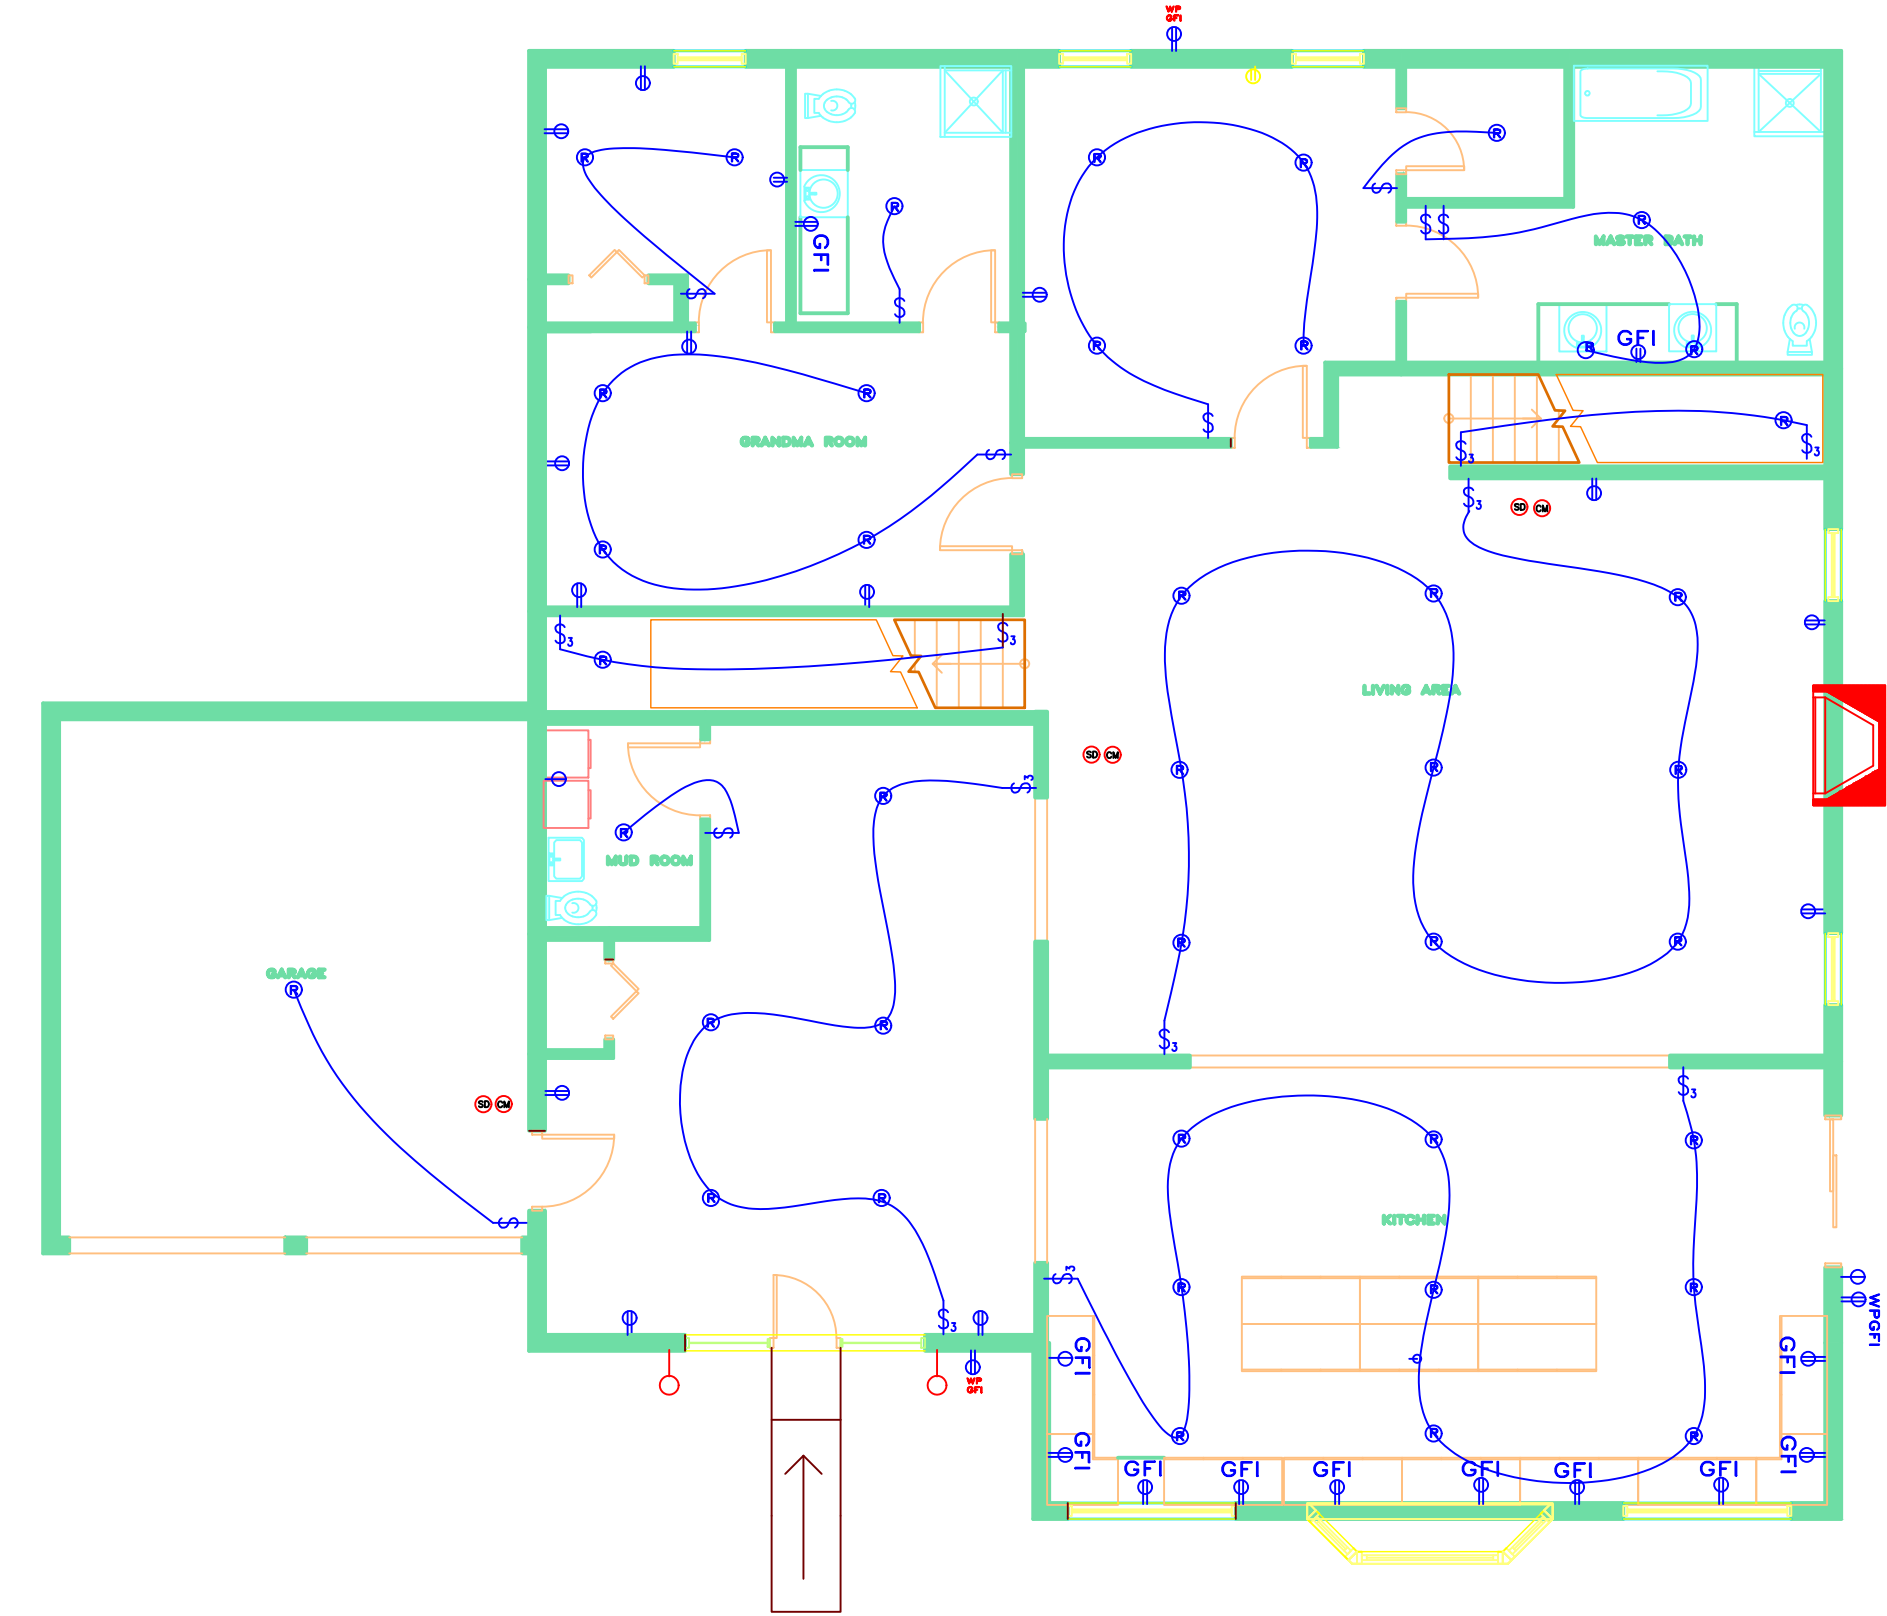

A
004

FIRST ELECTRICAL PLAN

SCALE 1/4"=1'-0"

SHEET TITLE



ROSANN ROMANO

PROJECT 1

SCALE 1/4"

DRAWING

REF: _____
PROJECT NO: _____
DATE: _____
FILE: SITE_PLAN_PROJ_1A
CONSTRUCTION
DESIGN 3.20.17.DWG
DRAWN BY: _____
CHK'D BY: _____

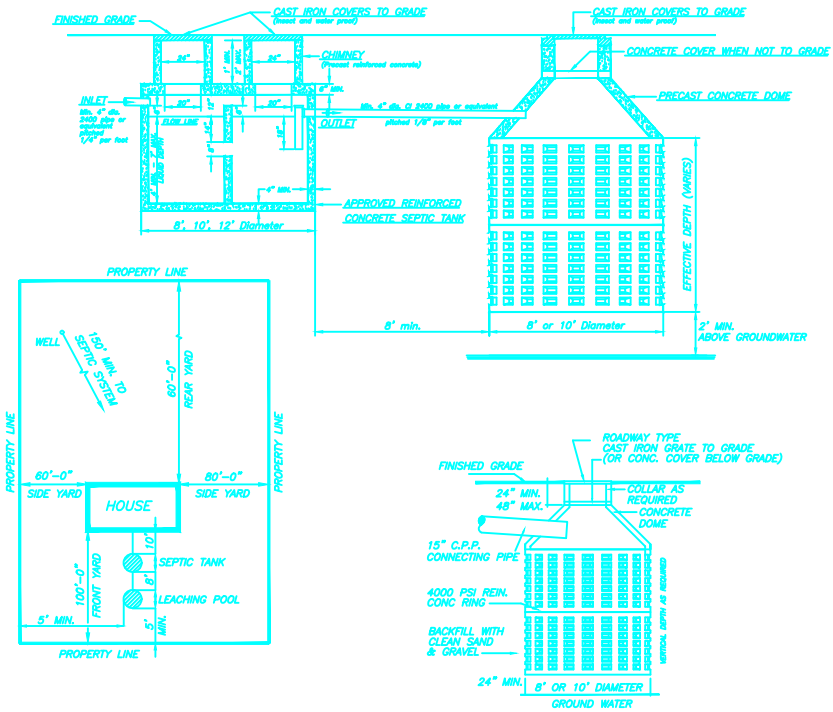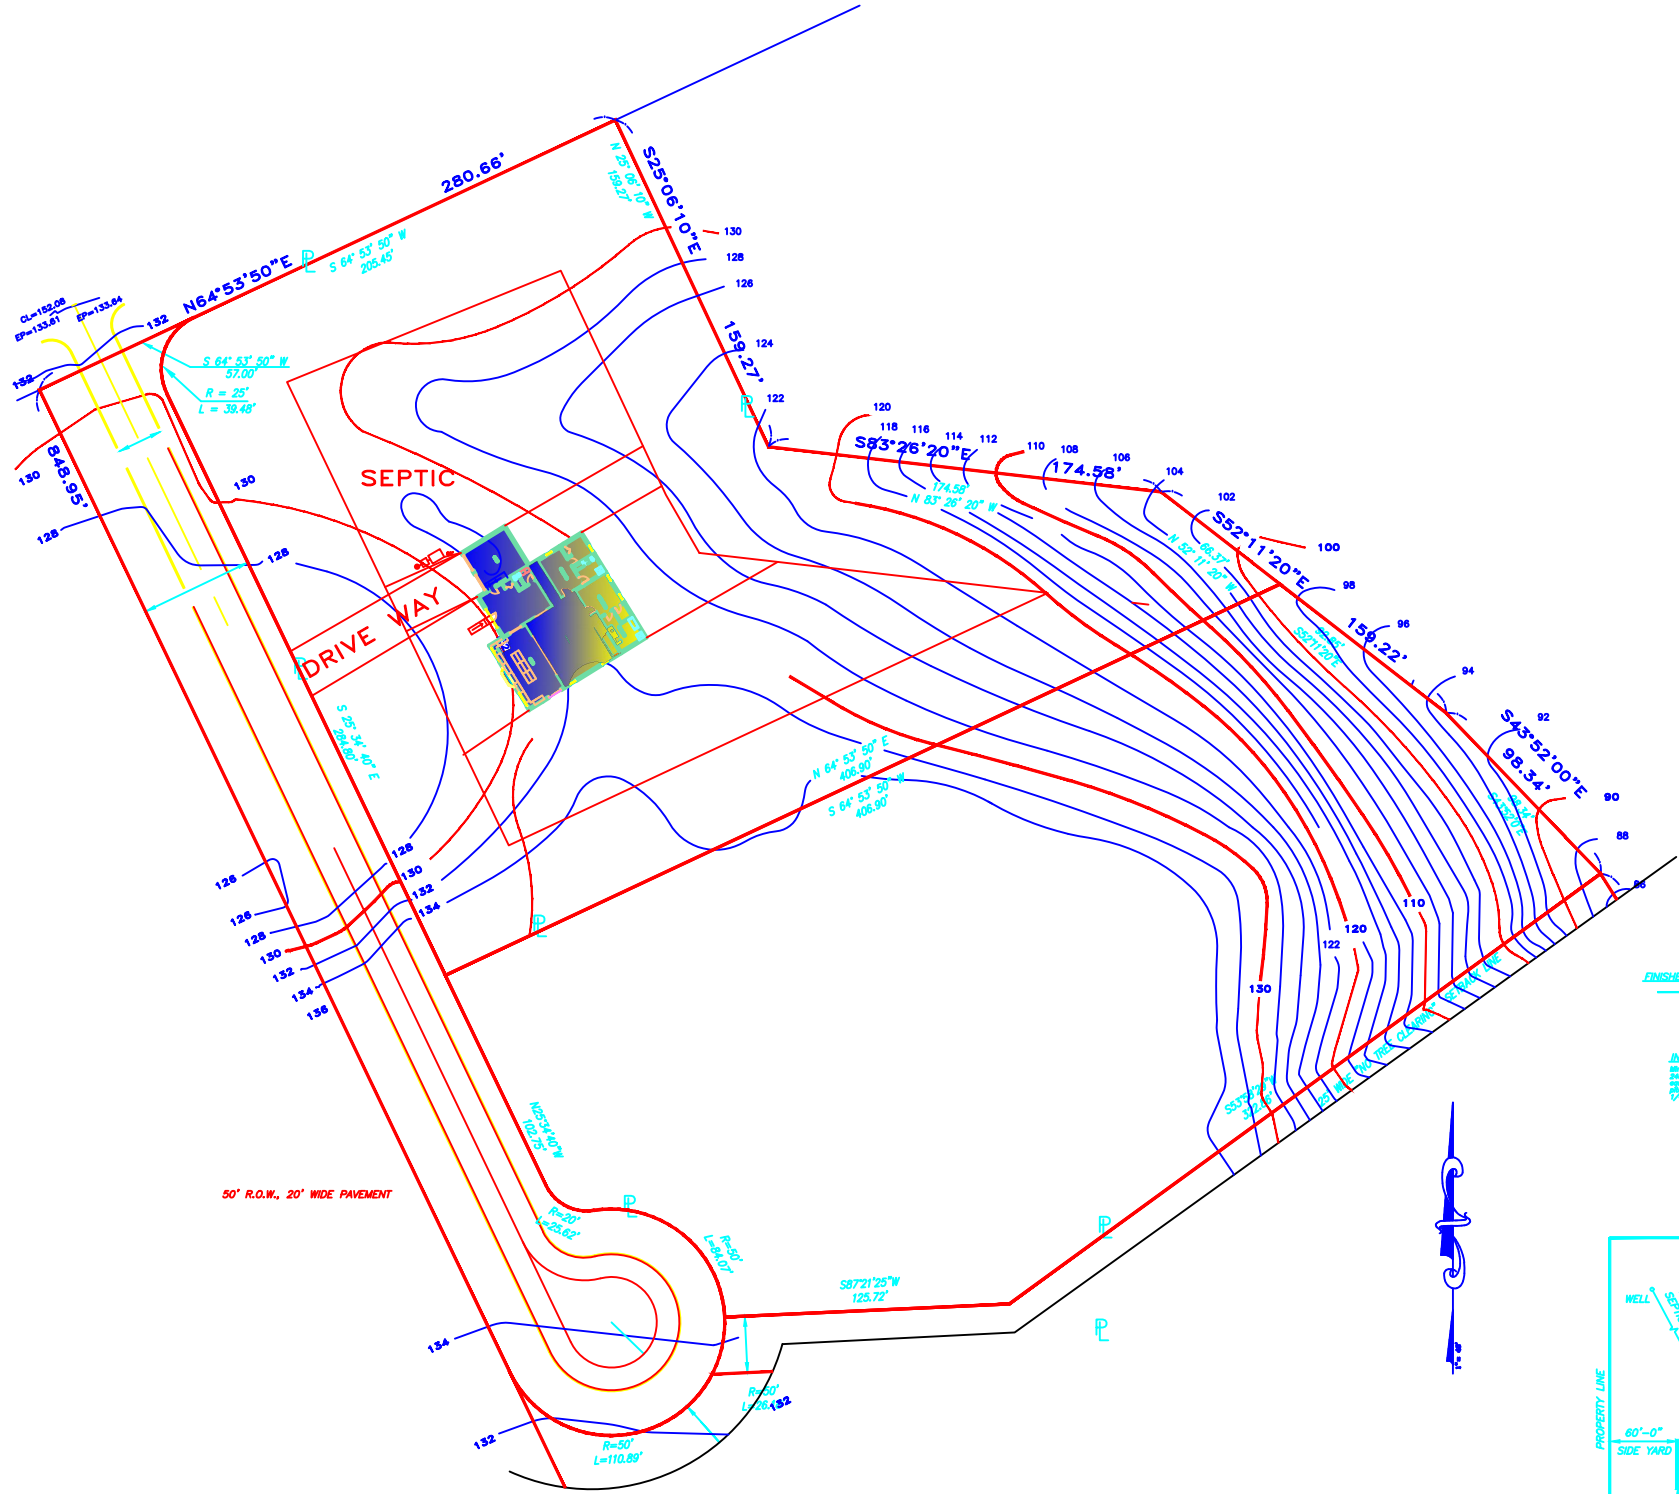

SHEET TITLE

ROSANN ROMANO

PROJECT 1

SCALE 1/4

DRAWING

REF: _____
PROJECT NO: _____
DATE: _____
FILE: SITE PLAN PROJ 1A
CONSTRUCTION
DESIGN 3.20.17.DWG
DRAWN BY: _____
CHK'D BY: _____

